
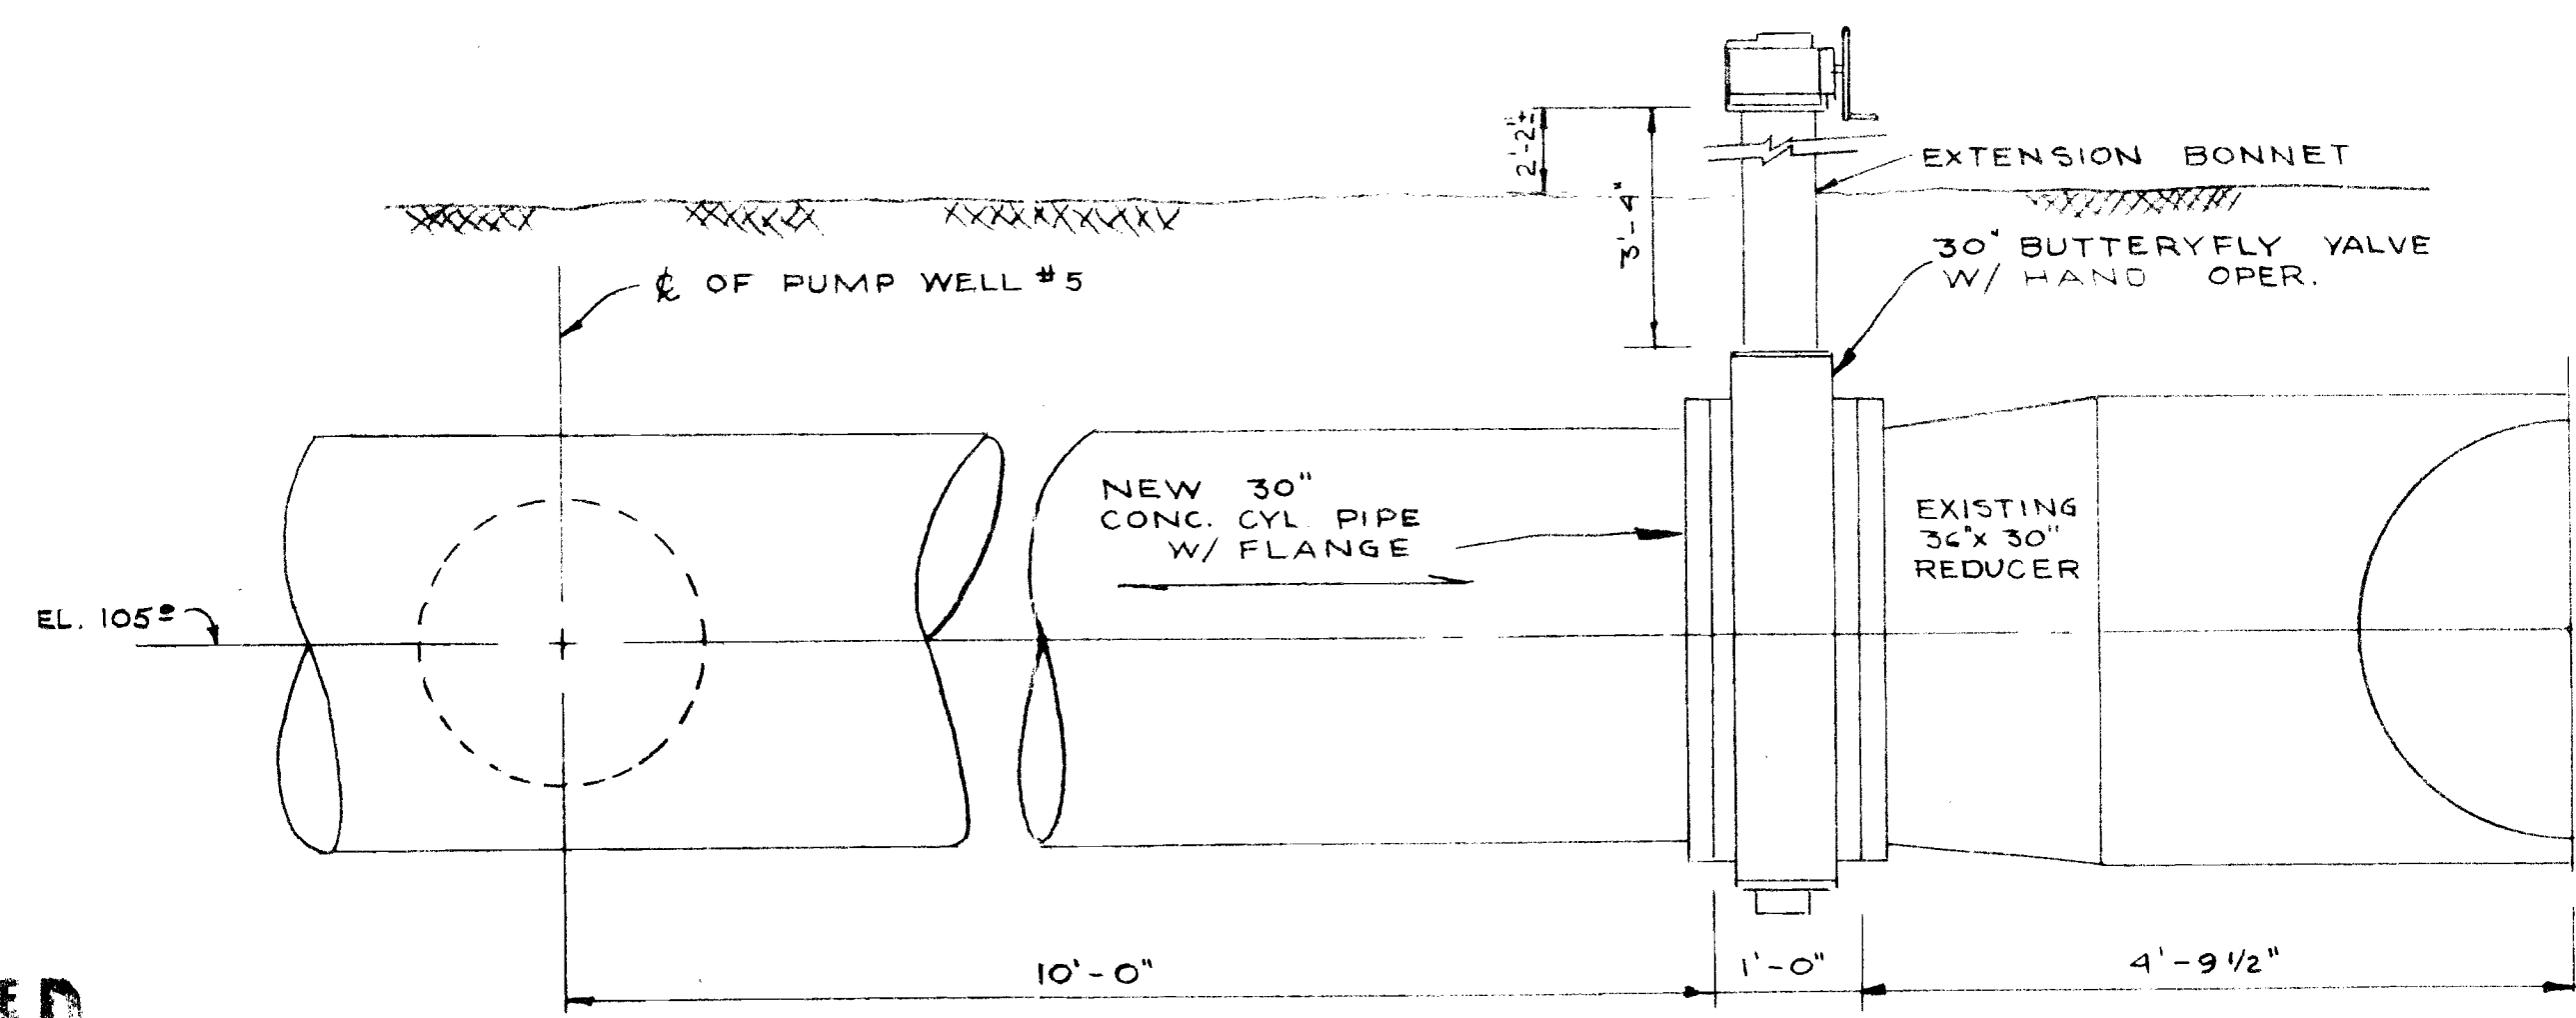


PLUMBING PLAN
SCALE: 1" = 50'

PIPE SCHEDULE

---	16" CONC. CYL. PIPE SUPPLY
---	30" CONC. CYL. PIPE SUPPLY
---	EXISTING PIPES
---	18 ALUM. C.M.P.
---	24" ALUM. C.M.P.

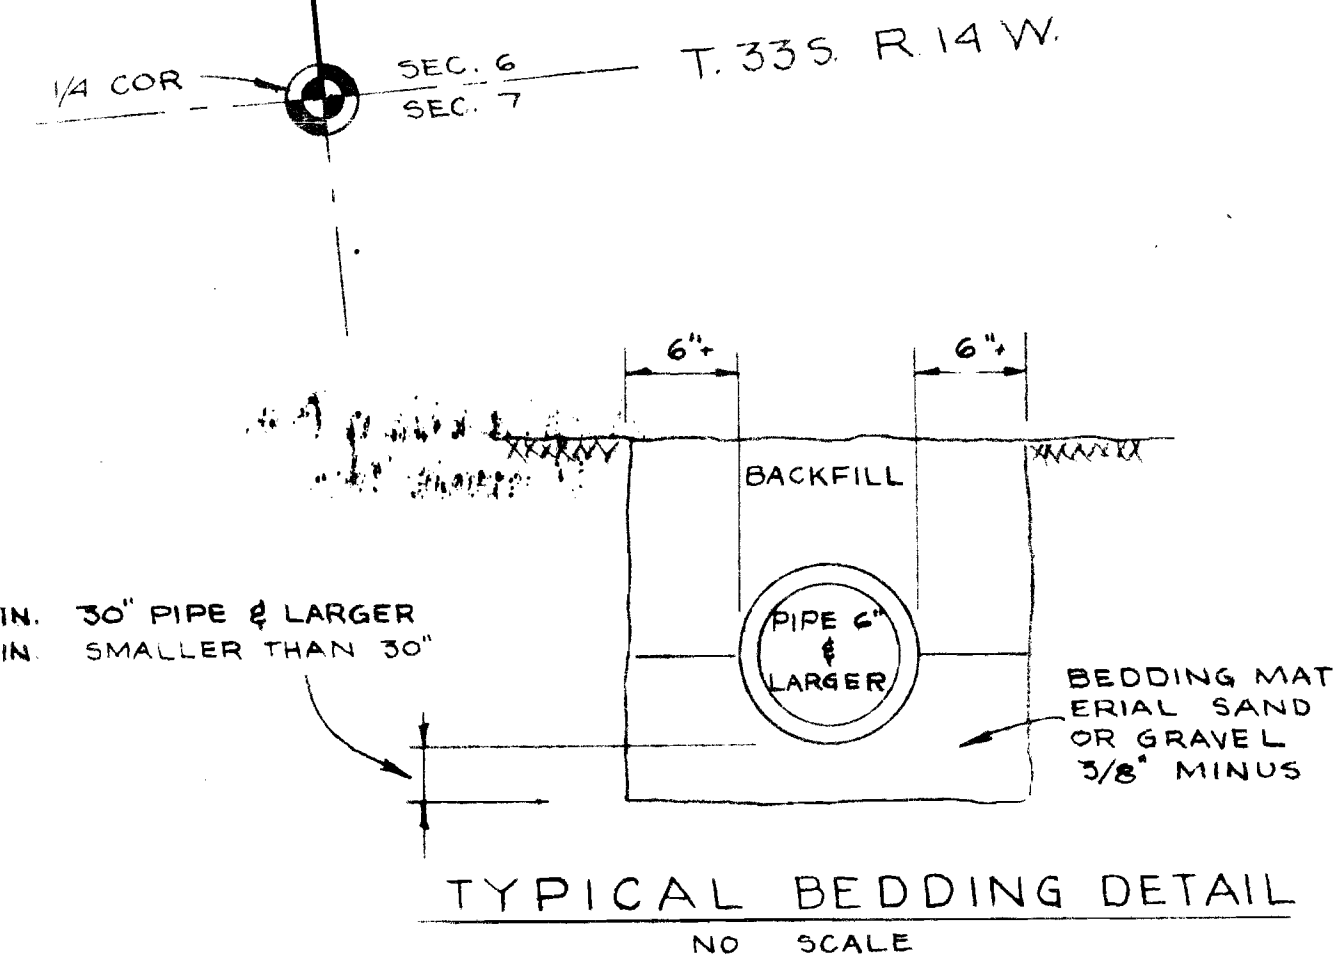

SECTION B-B
SCALE: 3/4" = 1'-0" 7/33

RECEIVED
APR 13 1971
STATE ENGINEER
SALEM, OREGON

Application No. 48100
Permit No. 35711 2

RECEIVED
APR 22 1971
STATE ENGINEER
SALEM, OREGON

REVISIONS			FISH COMMISSION STATE OF OREGON ELK RIVER SALMON HATCHERY EXPANSION PHASE - A PIPING PLAN
	DATE: 2-12-71	APPVD: <i>Robert W. Johnson</i>	FISHERIES DIRECTOR
	DESIGN BY: CRC	APPVD: <i>William H. ...</i>	DIRECTOR OF ENGR.
	DRAWN BY: BME	FILE NO. HI7-7001A	SHT. 3 OF 12
CHECKED BY: F.M.			