
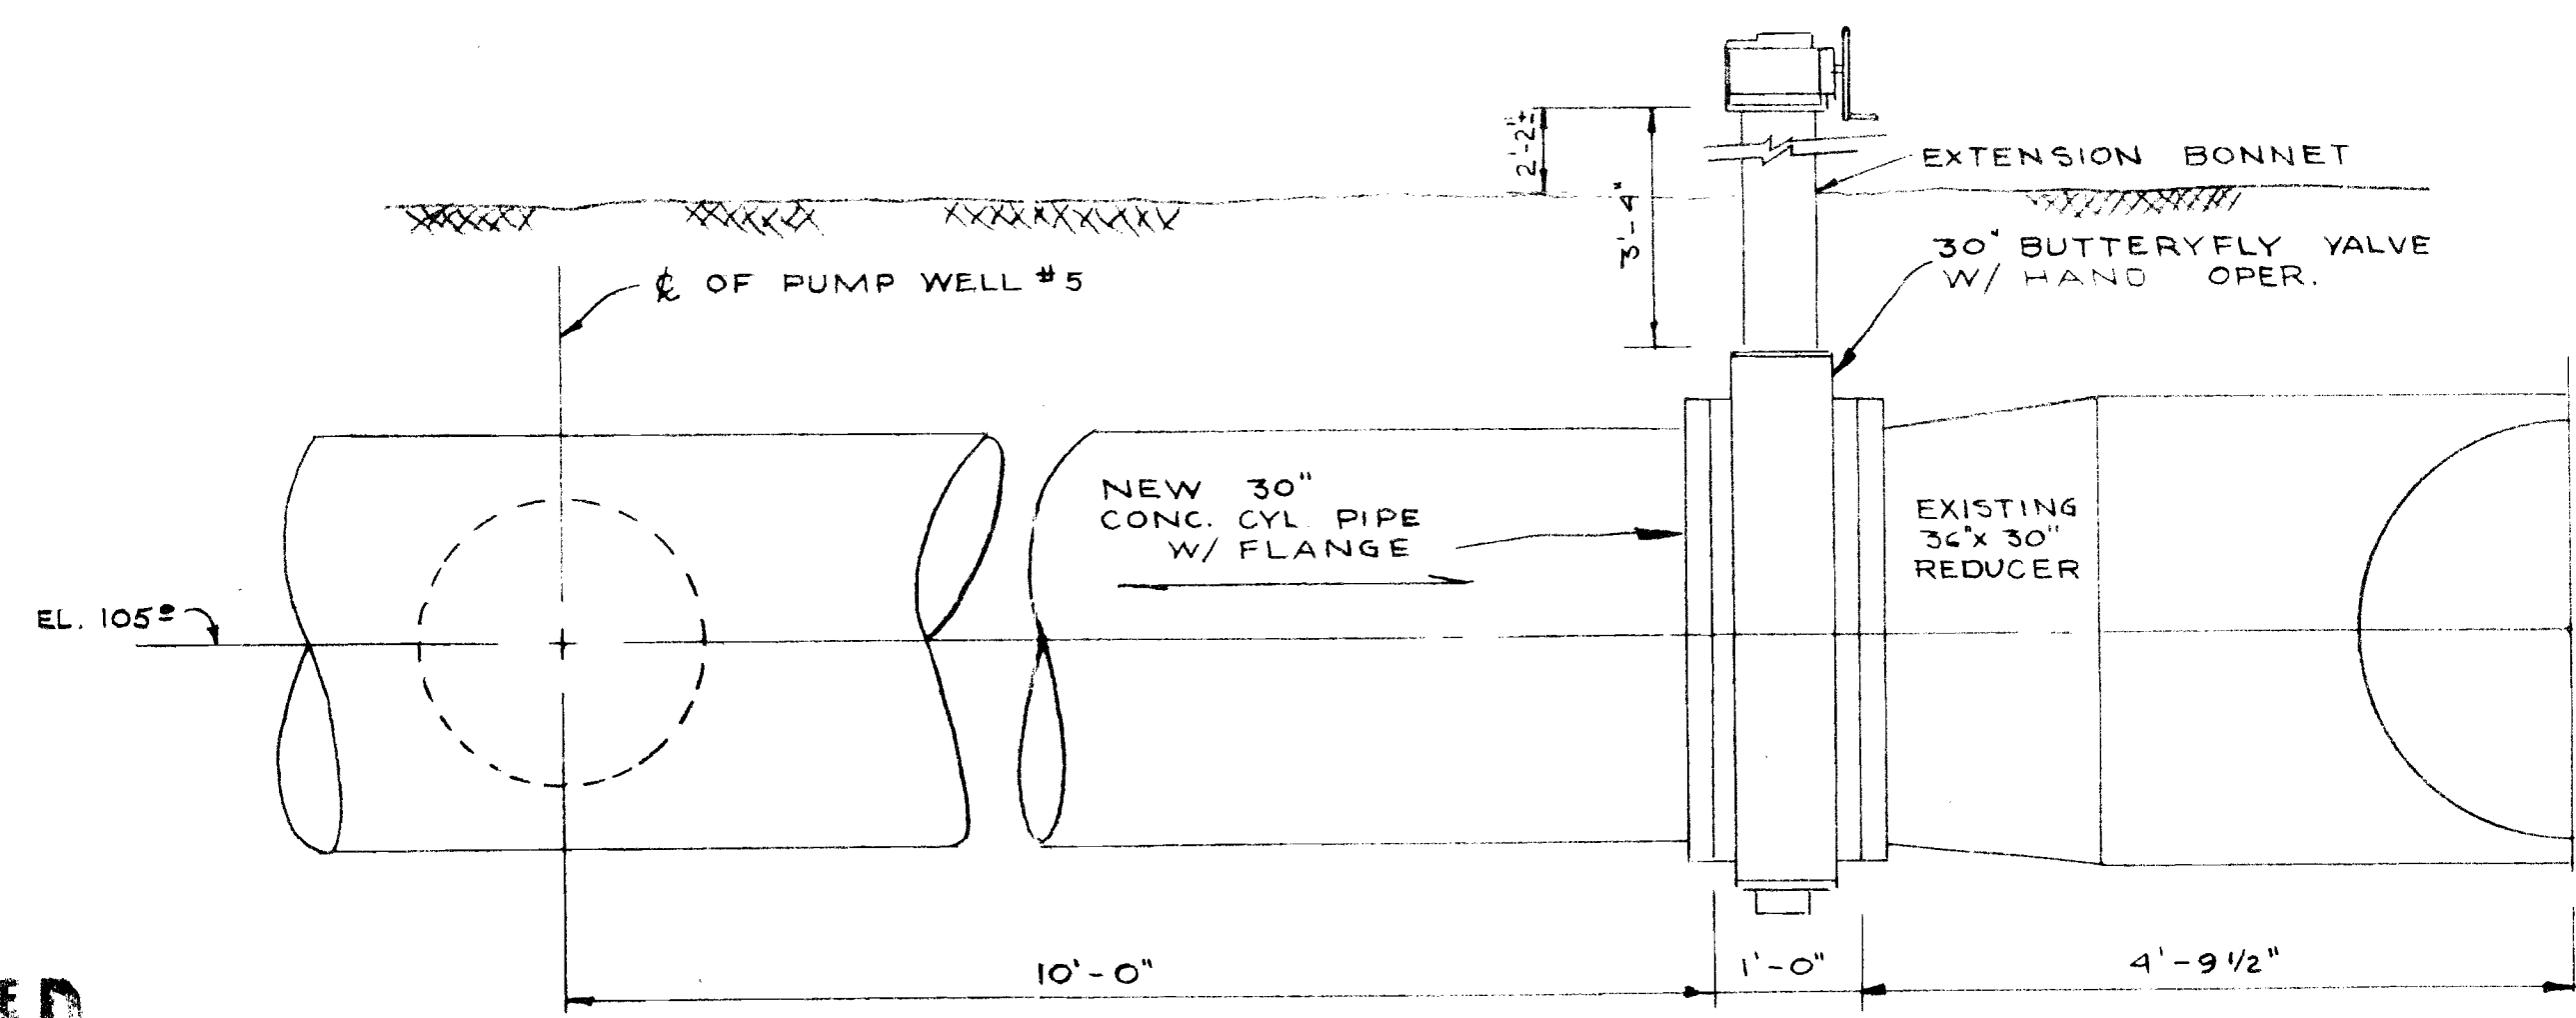


**PLUMBING PLAN**  
SCALE: 1" = 50'

**PIPE SCHEDULE**

---	16" CONC. CYL. PIPE SUPPLY
---	30" CONC. CYL. PIPE SUPPLY
---	EXISTING PIPES
---	18 ALUM. C.M.P.
---	24" ALUM. C.M.P.

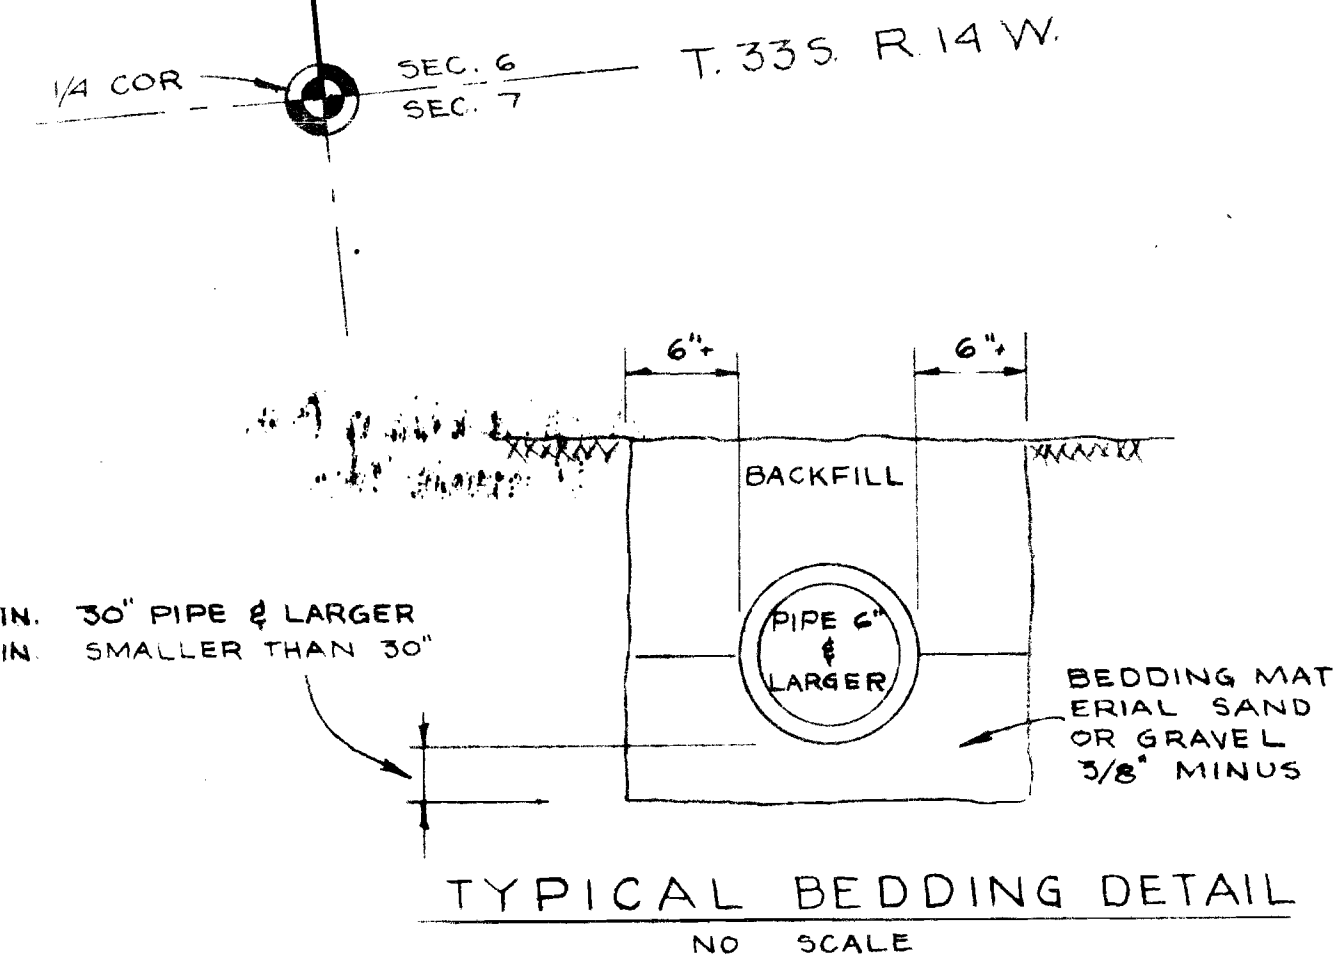

**Application No. 48100**  
**Permit No. 35711 2**

**RECEIVED**  
APR 22 1971  
STATE ENGINEER  
SALEM, OREGON

REVISIONS			<b>FISH COMMISSION</b> STATE OF OREGON ELK RIVER SALMON HATCHERY EXPANSION PHASE - A <b>PIPING PLAN</b>
	DATE: 2-12-71	APPVD: <i>Robert W. Johnson</i>	FISHERIES DIRECTOR
	DESIGN BY: CRC	APPVD: <i>William L. ...</i>	DIRECTOR OF ENGR.
	DRAWN BY: BME	FILE NO. HI7-7001A	SHT. 3 OF 12
CHECKED BY: F.M.			