


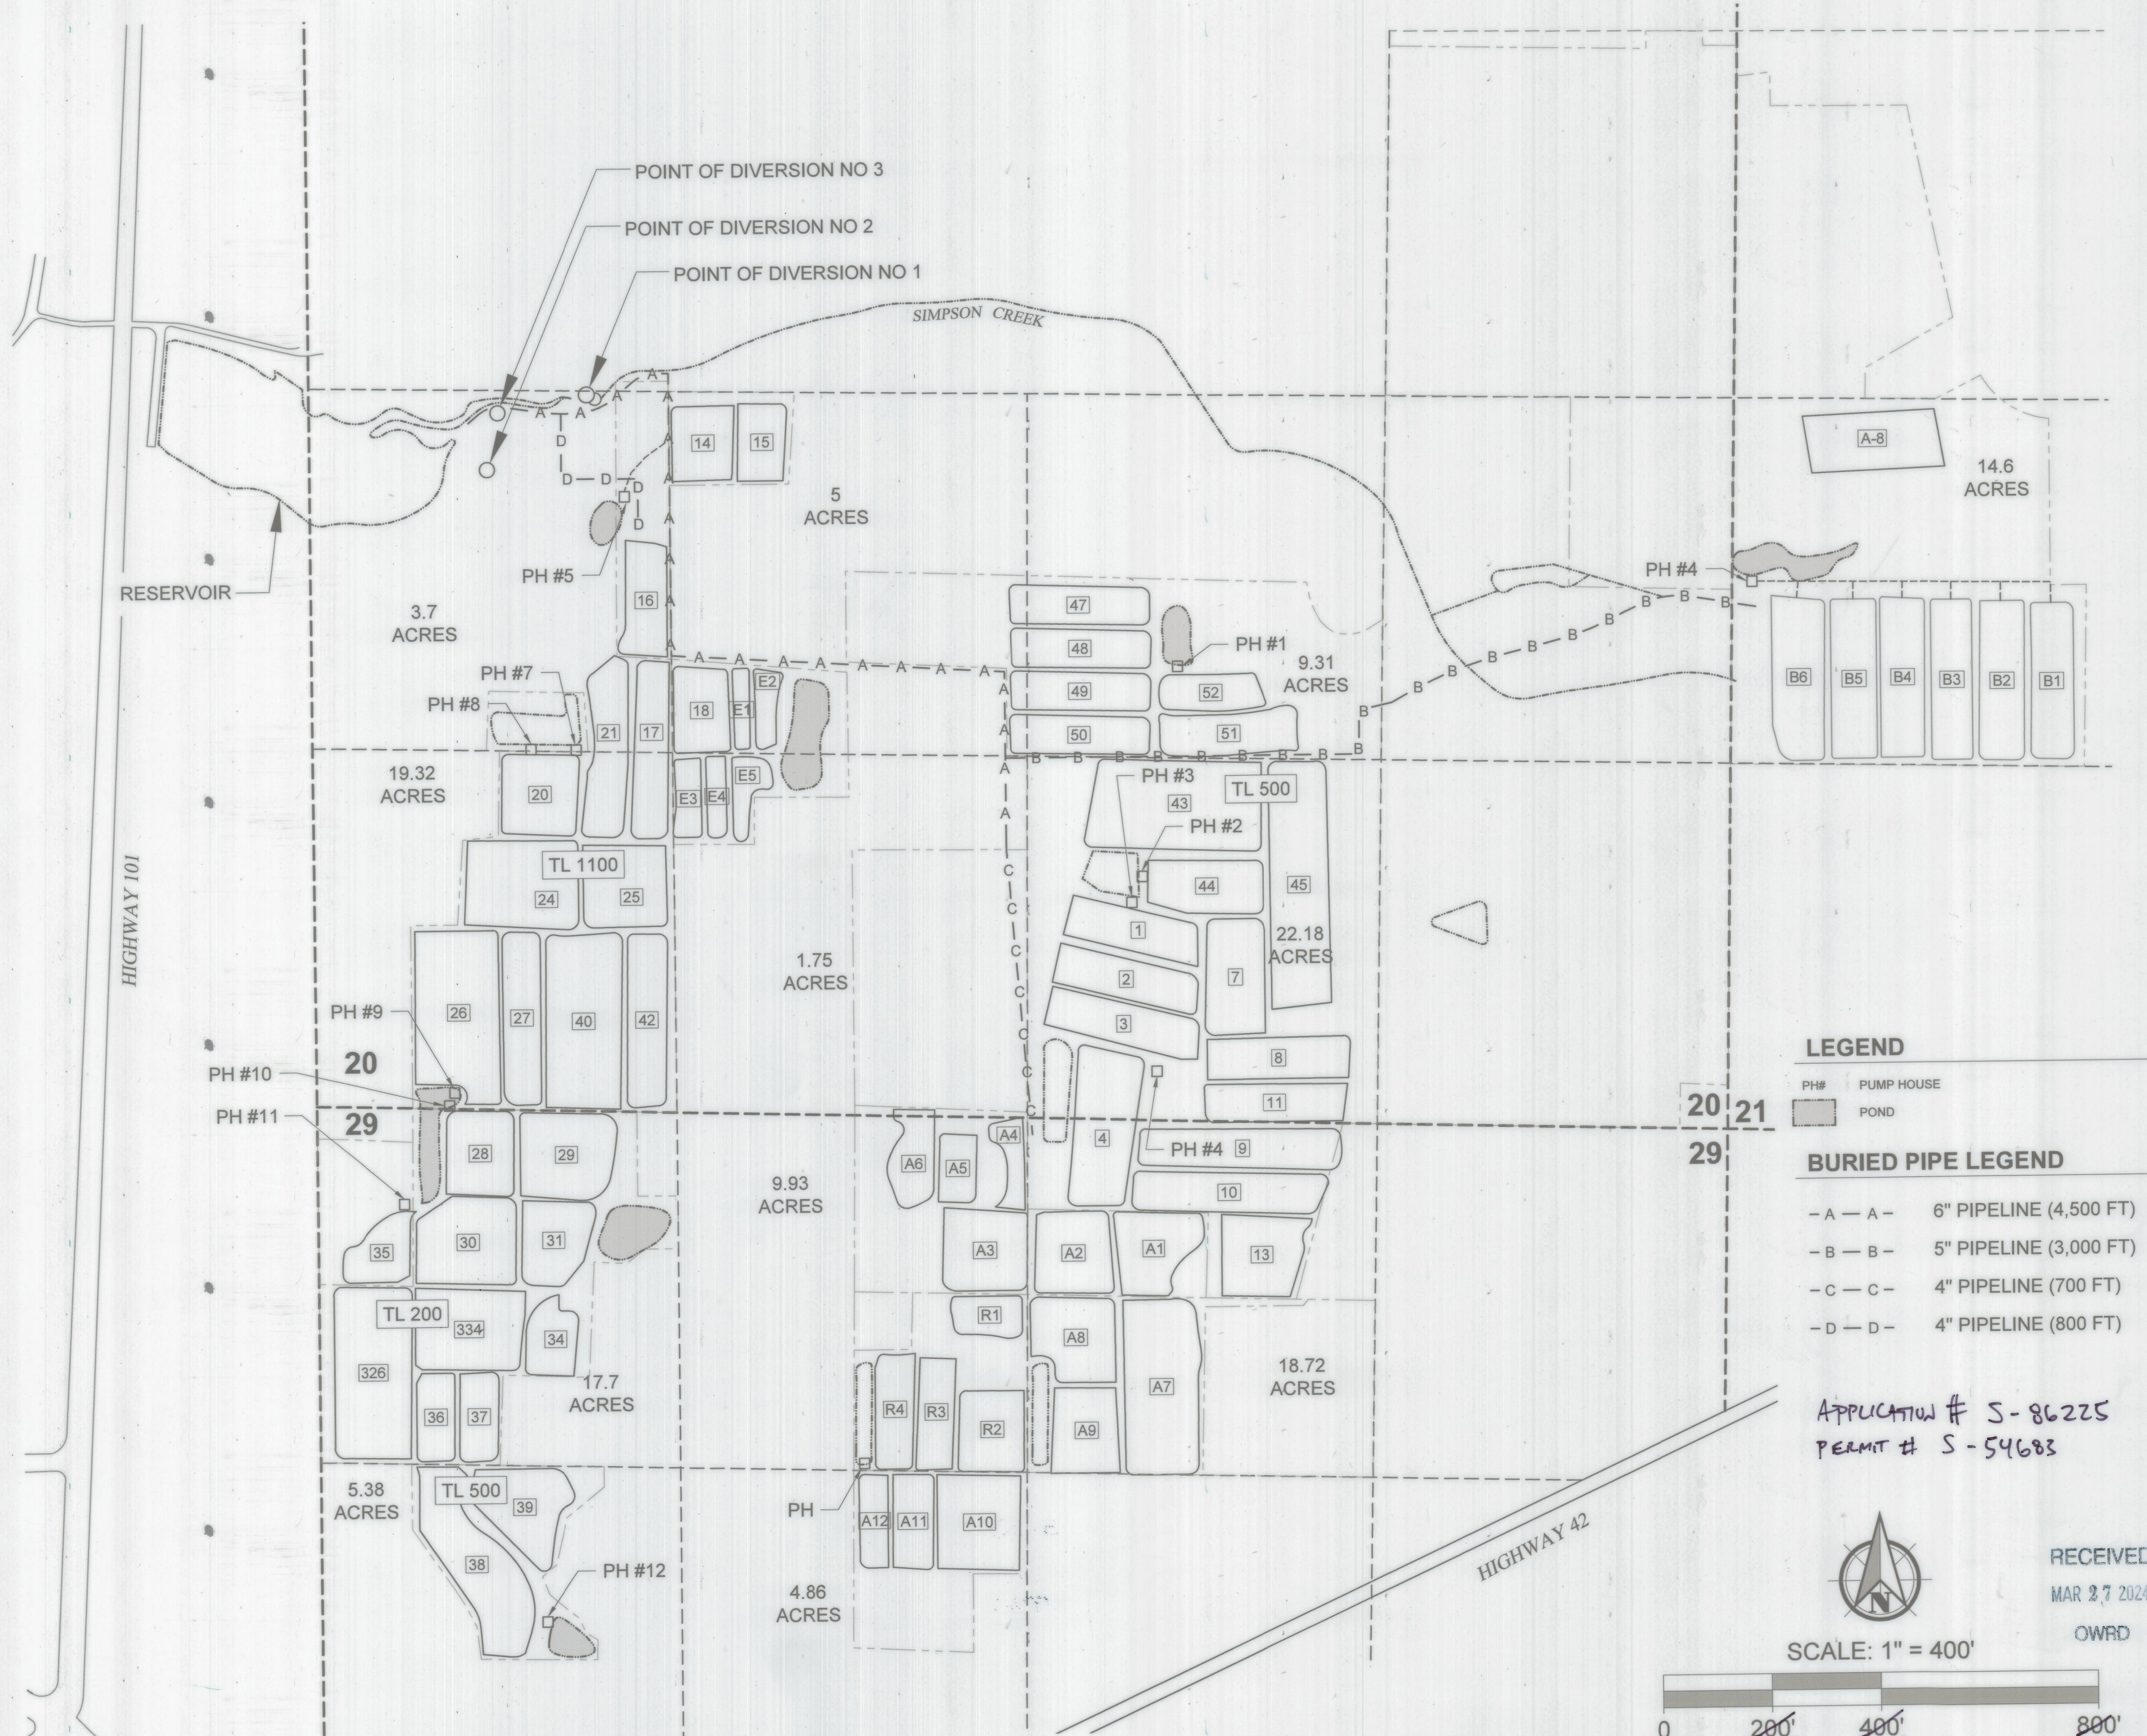

LEGEND

PH# PUMP HOUSE
POND


BURIED PIPE LEGEND

- A - A - 6" PIPELINE (4,500 FT)
- B - B - 5" PIPELINE (3,000 FT)
- C - C - 4" PIPELINE (700 FT)
- D - D - 4" PIPELINE (800 FT)

APPLICATION # S-86225
PERMIT # S-54683



SCALE: 1" = 400'

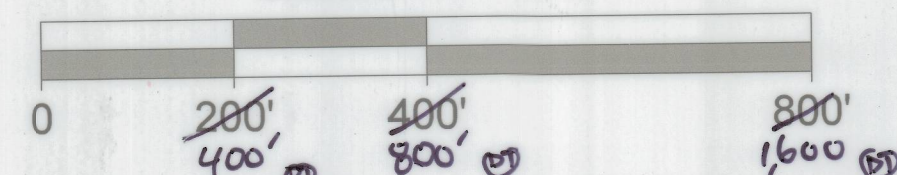

PREPARED FOR: PROSPER SUB-DISTRICT

RECEIVED
MAR 27 2024
OWRD

SITE PLAN

SECTIONS 20, 21, AND 29, TOWNSHIP 28 SOUTH
RANGE 14 WEST, W.M., BANDON, OREGON

DRAWN BY
KJB
CHECKED:
DT
DATE:
OCTOBER 2023
PROJECT NUMBER:
90295.000

SHEET DRAWING NO:

1

SHEET 1 OF 1

PBS Engineering and
Environmental Inc.
1325 SE Tech Center Drive,
Suite 140
Vancouver, WA 98683
360.695.3488
pbsusa.com



Certified Water Right Examiner
92041
DENNIS MICHAEL TERZIAN
JULY 17, 2017
STATE OF OREGON
Expires: 6/30/2024

THIS MAP IS NOT INTENDED TO PROVIDE LEGAL DIMENSIONS OR LOCATIONS OF PROPERTY OWNERSHIP LINES
FULL SIZE SHEET FORMAT IS 18X24; IF PRINTED SIZE IS NOT 18X24, THEN THIS SHEET FORMAT HAS BEEN MODIFIED & INDICATED DRAWING SCALE IS NOT ACCURATE.