


7

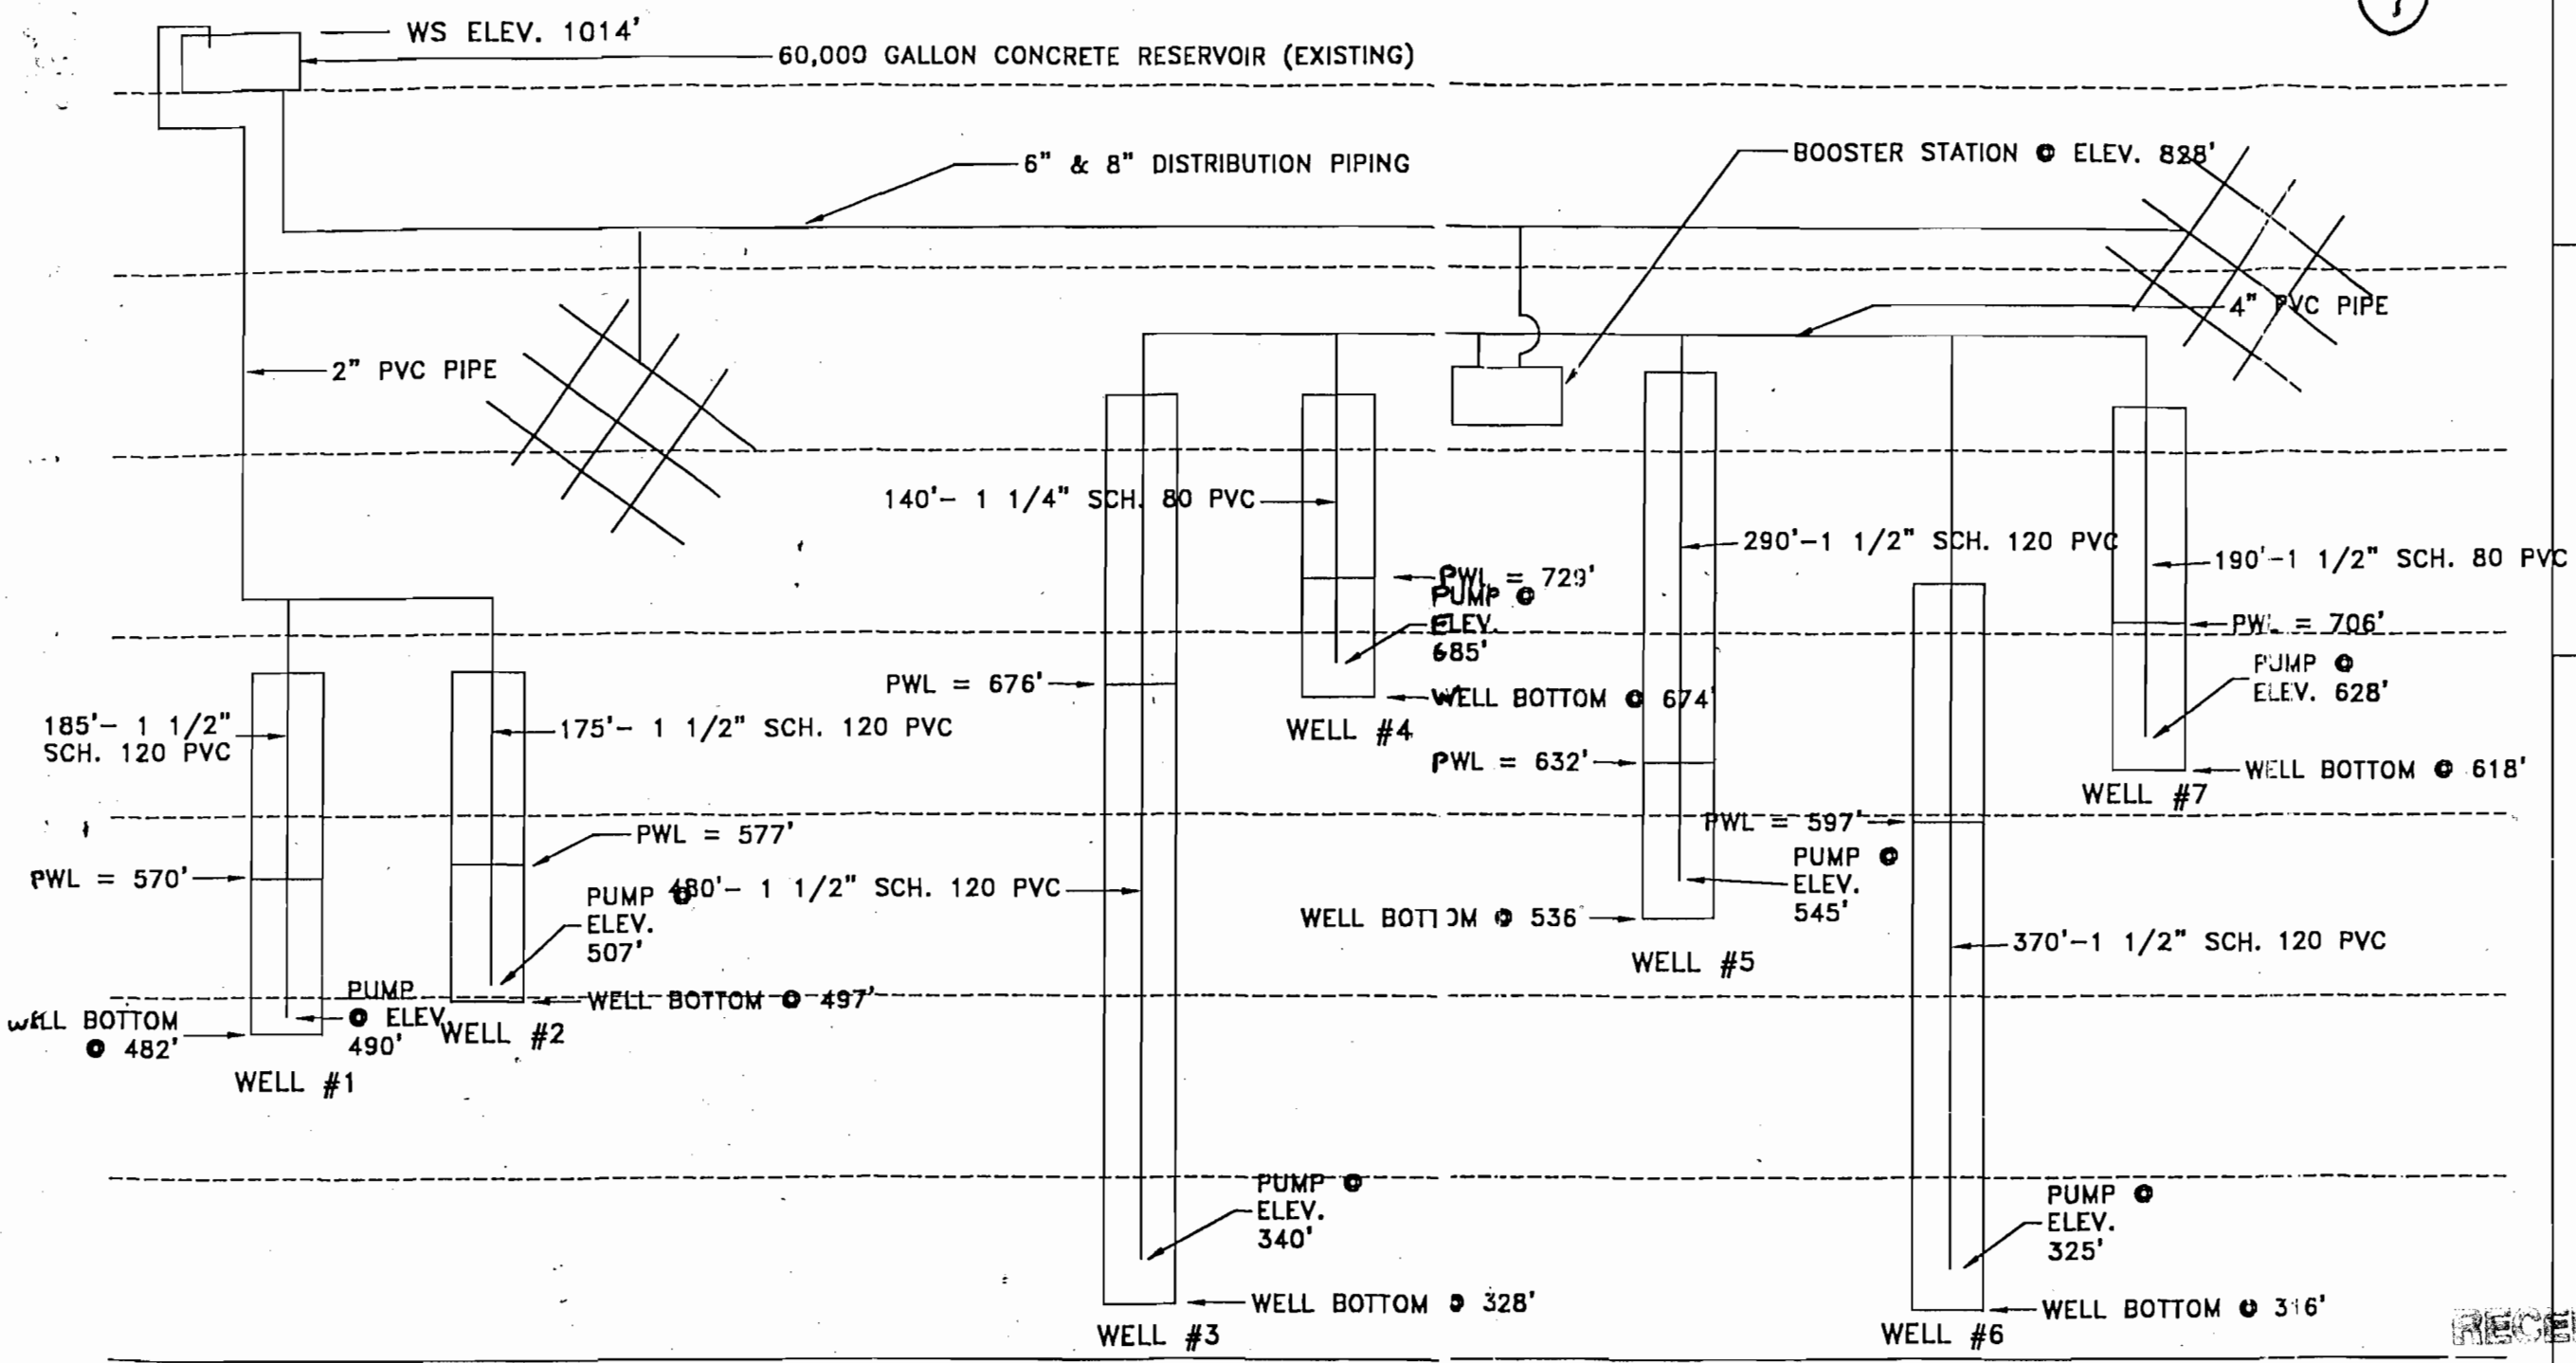


PUMP SCHEDULE

WELL #	PUMP #	HP	SETTING (B.G.S.)	FLOW (gpm)	HEAD (FT)
1	GOULD 10GS20412	2	187'	7	600
2	GOULD 10GS20412	2	177'	7	600
3	GOULD 5GS05412	5	482'	7	170
4	GOULD 10GS05412	5	142'	11	114
5	GOULD 18GS20412	2	292'	24	232
6	GOULD 7GS07412	.75	372'	9	248
7	GOULD 40GS20412	2	192'	34	139
BOOSTER #1	GRUNDFOS 40S50-12	5	ELEV. 820'	52	200
BOOSTER #2	GRUNDFOS 40S50-12	5	ELEV. 820'	52	200

HAWK'S POINT SYSTEM SCHEMATIC

STETTLER COMPANY
 1810 LANA AVENUE, NE.
 SALEM, OREGON 97303
 (503) 585-5550

*** WARNING ***
 CALL BEFORE YOU DIG
 1-800-332-2344

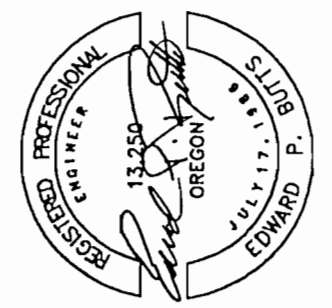

RECEIVED

DEC 9 1998

WATER RESOURCES DEPT
 SALEM, OREGON

VALLECITOS ASSOCIATES
 HAWK'S POINT SUBDIVISION
 WATER SYSTEM UPGRADE

OPERATIONAL SCHEMATIC

RECEIVED

DEC 7 1999

WATER RESOURCES DEPT
 SALEM, OREGON

BY	REVISIONS DESCRIPTION	DATE

JOB #: 98-3221 FILE: C:\DRAWINGS\HAWK'S
 DATE: 09-15-98 SCALE: AS SHOWN
 DRAWN BY: JMS REVIEWED BY: EPB