
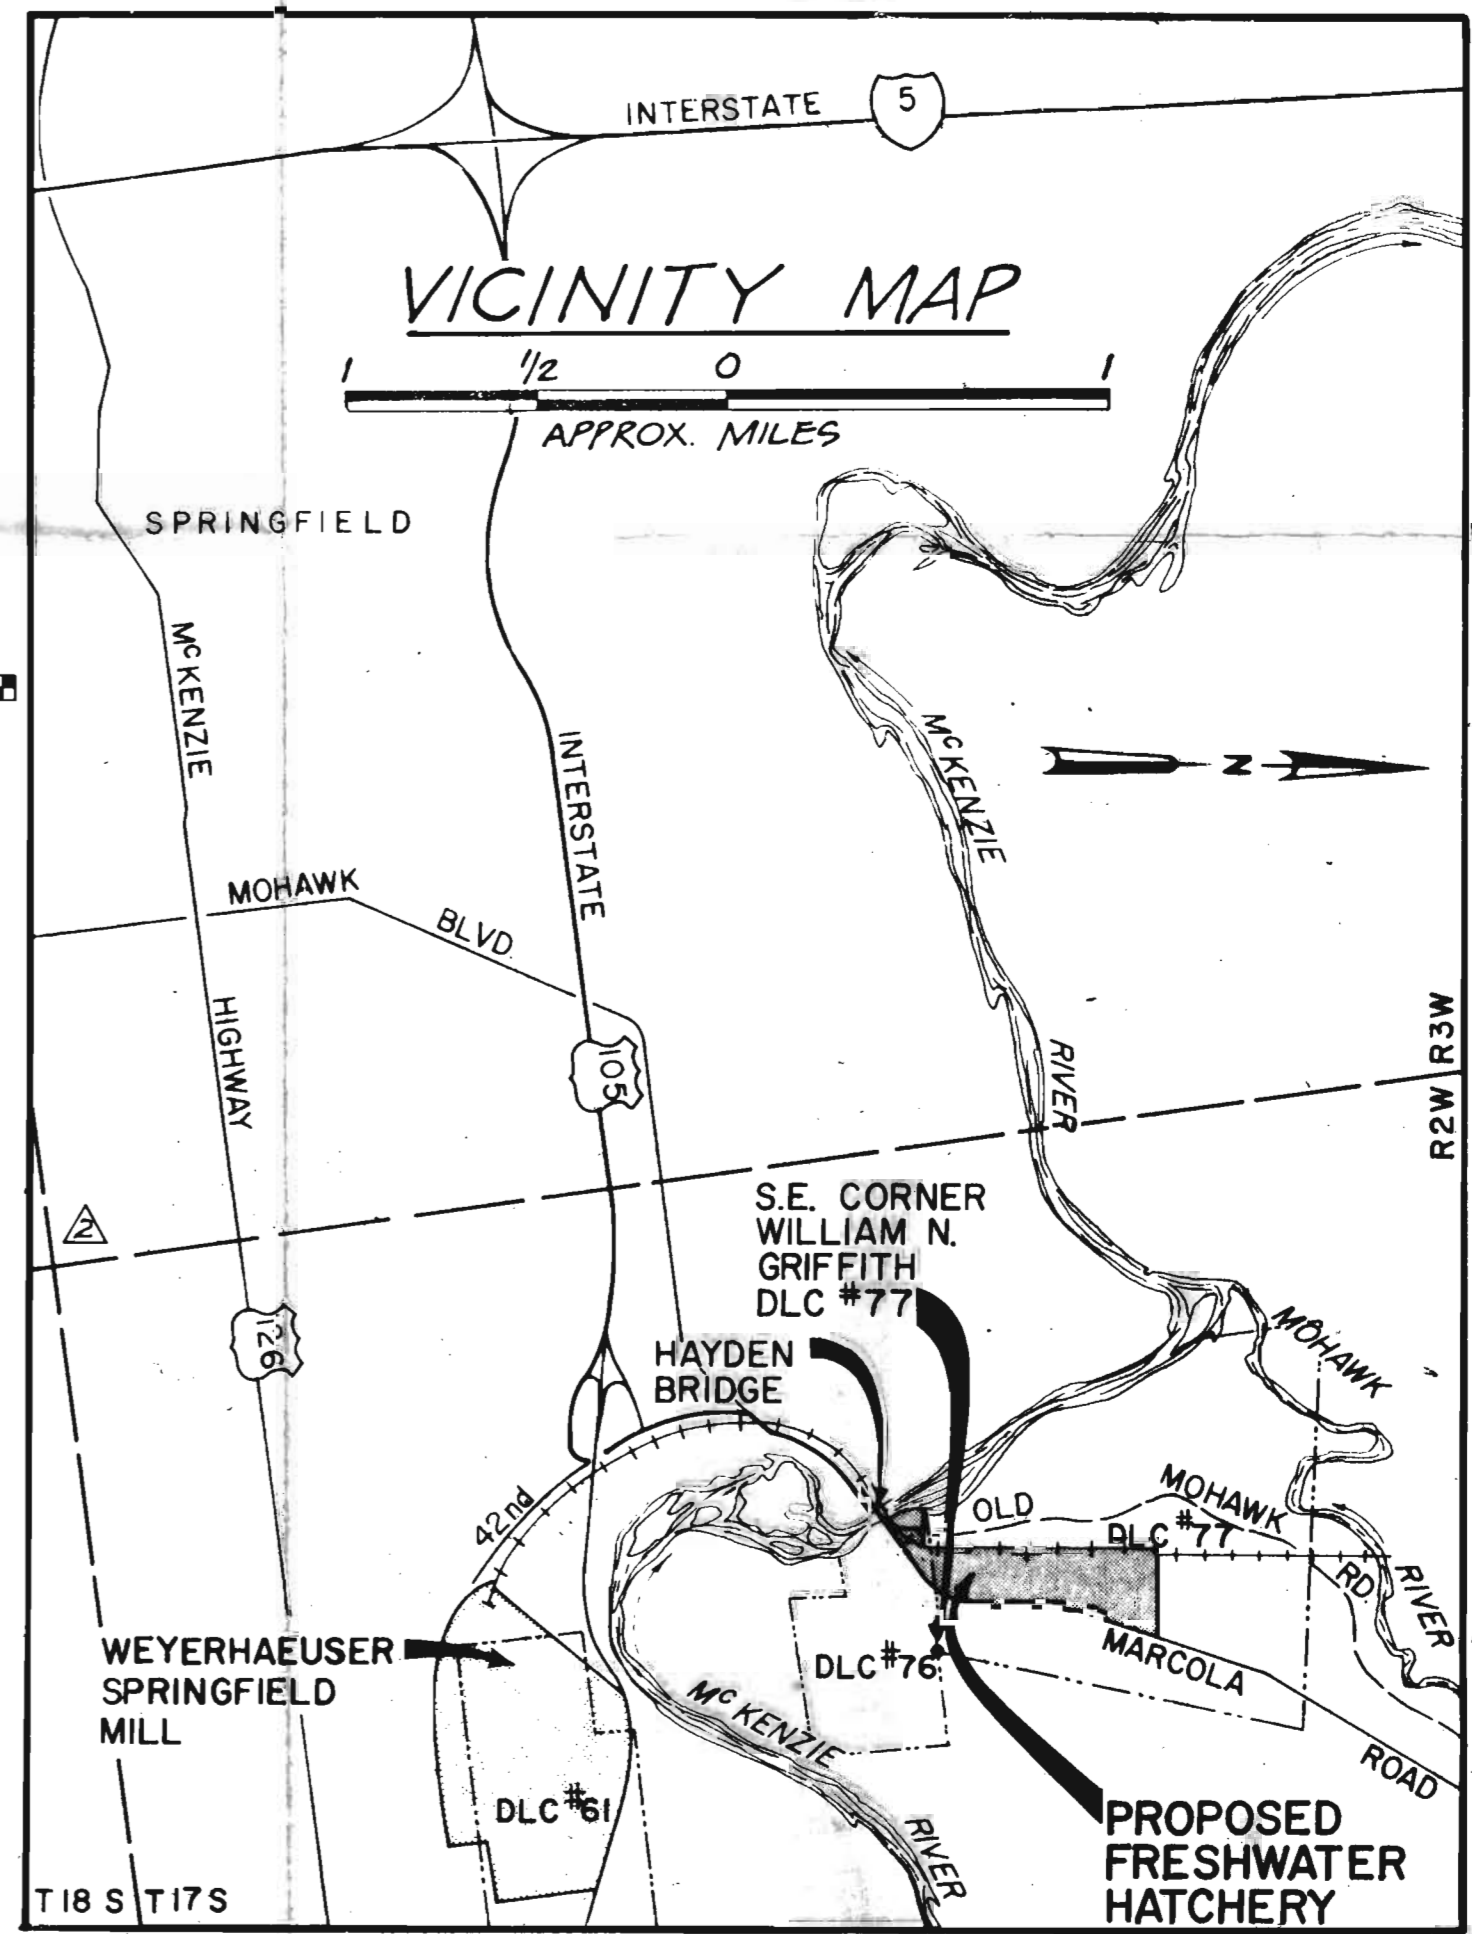
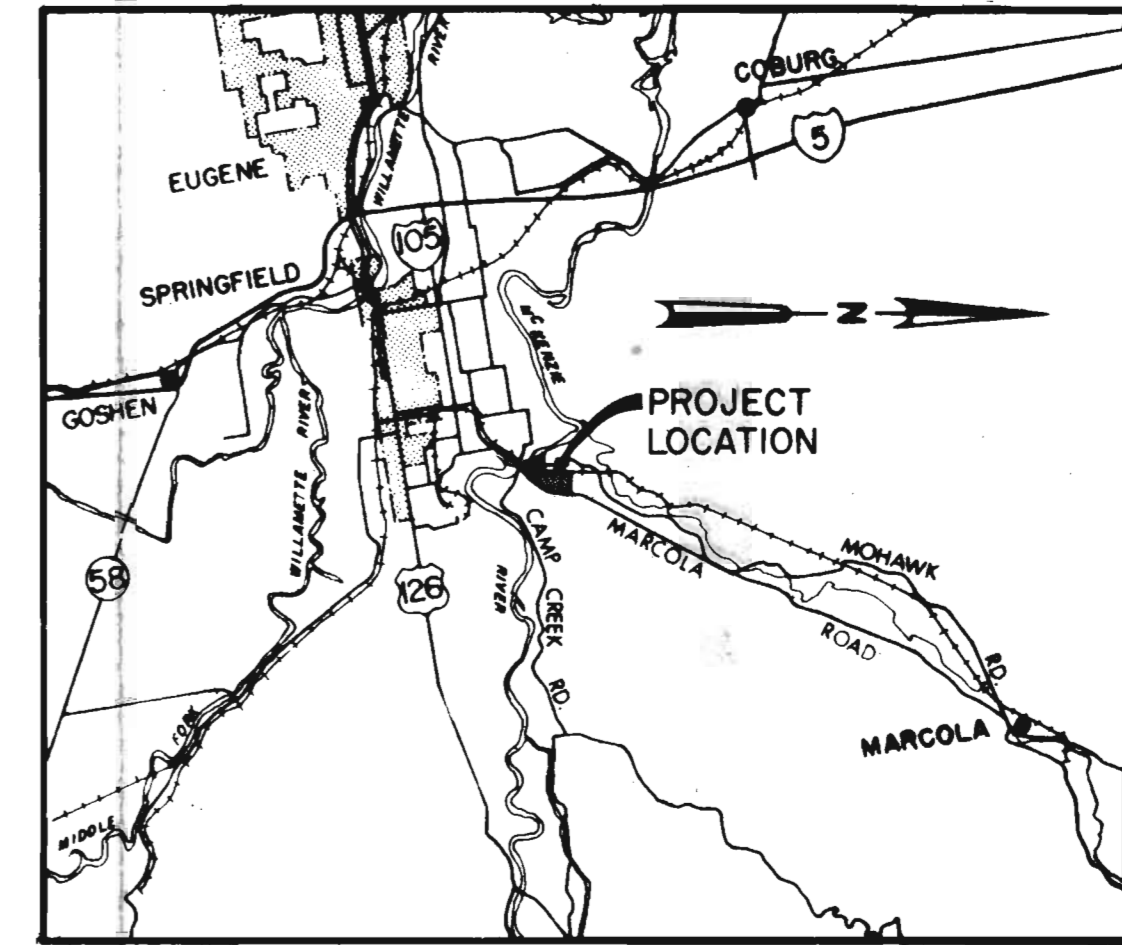


# WEYERHAEUSER COMPANY

# FRESHWATER HATCHERY GENERAL SPRINGFIELD, OREGON

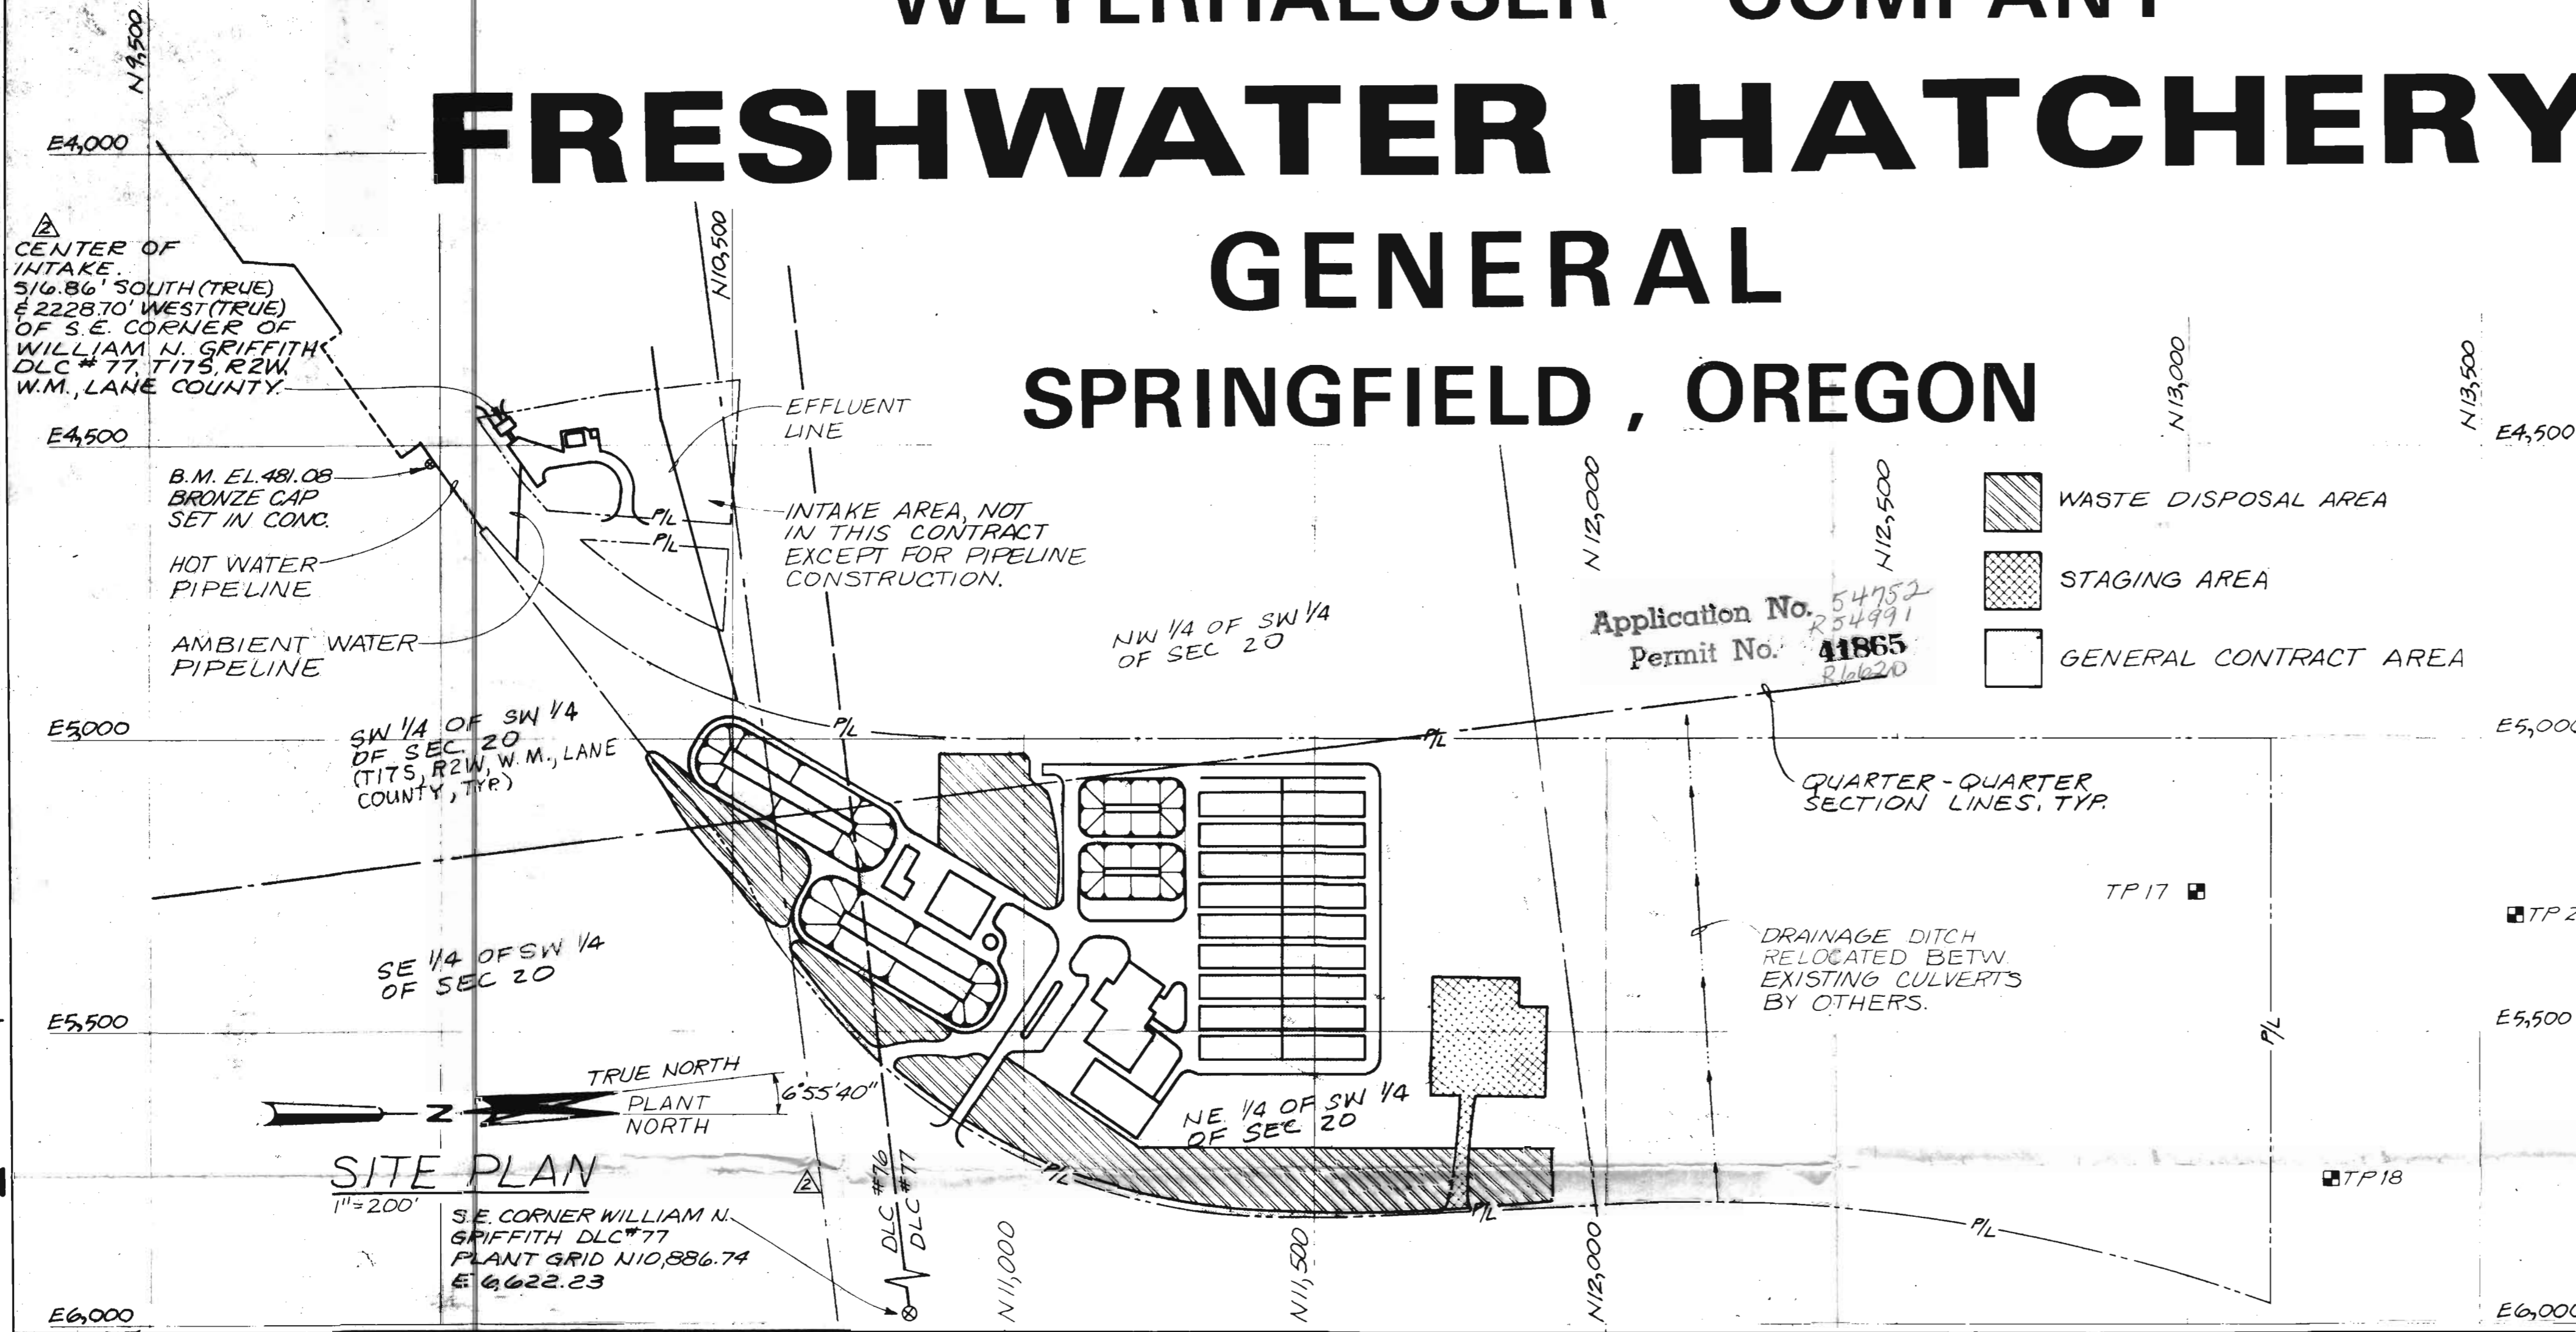

Application No. 54952  
Permit No. 41865

- WASTE DISPOSAL AREA
- STAGING AREA
- GENERAL CONTRACT AREA

SHEET NO.	DRAWING TITLE	SHEET NO.	DRAWING TITLE	SHEET NO.	DRAWING TITLE	SHEET NO.	DRAWING TITLE
1.	SITE PLAN, VICINITY MAP AND INDEX TO DRAWINGS	28.	SANITARY WASTE HOLDING TANK, AND MISCELLANEOUS DETAILS	51.	HATCHERY BUILDING STRUCTURAL FOUNDATION DETAILS	69.	CHLORINATION - DECHLORINATION BUILDING EQUIPMENT AND PIPING LAYOUT PLAN
2.	LEGEND	29.	R & D AND SERVICE WATER SUPPLY PUMP STATION	52.	HATCHERY BUILDING STRUCTURAL DETAILS	70.	CHLORINATION - DECHLORINATION BUILDING EQUIPMENT AND PIPING LAYOUT SECTIONS AND DETAILS
3.	LEGEND	30.	LAYOUT AND GRADING PLAN	53.	HATCHERY BUILDING STRUCTURAL DETAILS	71.	CHLORINATION - DECHLORINATION BUILDING EQUIPMENT AND PIPING LAYOUT SCHEMATICS
4.	TEST PIT AND BORING LOG LOCATION PLAN	31.	SEDIMENTATION BASIN PLAN AND SECTION	54.	HATCHERY BUILDING STRUCTURAL DETAILS	72.	CHLORINATION - DECHLORINATION BUILDING CHLORINE DIFFUSER DETAILS
5.	TEST PIT AND BORING LOGS	32.	SEDIMENTATION BASIN BAFFLE DETAILS	55.	HATCHERY BUILDING ARCHITECTURAL PARTIAL PLANS AND INTERIOR ELEVATIONS	73.	CHLORINATION - DECHLORINATION BUILDING HEATING AND VENTILATING PLAN
6.	TEST PIT LOGS	33.	SEDIMENTATION BASIN OUTLET STRUCTURE DETAILS	56.	HATCHERY BUILDING ARCHITECTURAL PARTIAL PLANS, INTERIOR ELEVATIONS AND WINDOW ELEVATIONS	74.	REARING PONDS GENERAL LAYOUT PLAN
7.	SITE GRADING PLAN	34.	NOT USED	57.	HATCHERY BUILDING ARCHITECTURAL REFLECTED CEILING PLAN	75.	REARING PONDS PARTIAL FOUNDATION PLAN
8.	SITE LAYOUT PLAN	35.	AMBIENT WATER RETENTION BASIN LAYOUT PLAN AND SECTIONS	58.	HATCHERY BUILDING POTABLE WATER TREATMENT FACILITY HVAC PLAN	76.	REARING PONDS FISH LOAD-OUT FACILITY PLAN
9.	EARTHWORK SECTIONS	36.	HOT WATER RETENTION TANK STRUCTURAL PLAN SECTION AND DETAILS	59.	HATCHERY BUILDING POTABLE WATER TREATMENT FACILITY HVAC SECTIONS AND DETAILS	77.	REARING PONDS FISH LOAD-OUT FACILITY SECTIONS
10.	EARTHWORK SECTIONS	36A.	HOT WATER RETENTION TANK MECHANICAL PLAN SECTION AND DETAILS	60.	HATCHERY BUILDING POTABLE WATER TREATMENT FACILITY HVAC MISCELLANEOUS DETAILS	78.	REARING PONDS STRUCTURAL SECTIONS AND DETAILS
11.	EARTHWORK SECTIONS	37.	HOT WATER RETENTION TANK PIPING DETAILS	61.	HATCHERY BUILDING POTABLE WATER TREATMENT FACILITY PLUMBING PLAN	79.	REARING PONDS STRUCTURAL SECTIONS AND DETAILS
12.	MISCELLANEOUS DETAILS	38.	RETENTION BASIN FLOW CONTROL BOXES APPURTENANT INSTALLATION DETAILS	62.	HATCHERY BUILDING POTABLE WATER TREATMENT FACILITY PLUMBING SECTIONS AND DETAILS	80.	REARING PONDS FISH LOAD-OUT RETAINING WALL ELEVATIONS
13.	ENTRANCE ROAD PROFILE AND MISCELLANEOUS DETAILS	39.	RETENTION BASIN FLOW CONTROL BOXES APPURTENANT INSTALLATION DETAILS	62A.	HATCHERY BUILDING POTABLE WATER TREATMENT FACILITY PLAN AND SECTIONS	81.	REARING PONDS TYPICAL MECHANICAL PLAN AND SECTIONS
14.	SITE PIPING PLAN, NORTH	40.	HATCHERY BUILDING STRUCTURAL FOUNDATION PLAN	63.	CHLORINATION - DECHLORINATION BUILDING STRUCTURAL FOUNDATION PLAN AND DETAILS	82.	REARING PONDS GATE AND SECTION DETAILS
15.	SITE PIPING PLAN, SOUTH	41.	HATCHERY BUILDING ARCHITECTURAL FLOOR PLAN	64.	CHLORINATION - DECHLORINATION BUILDING ARCHITECTURAL FLOOR PLAN	83.	REARING PONDS GATE AND SCREEN DETAILS
16.	SITE PLUMBING PLAN	42.	HATCHERY BUILDING ARCHITECTURAL ROOF PLAN	65.	CHLORINATION - DECHLORINATION BUILDING STRUCTURAL ROOF FRAMING PLAN AND DETAILS	83A.	REARING PONDS LOAD-OUT CHUTE DETAILS
17.	HAYDEN BRIDGE HOT WATER PIPELINE CROSSING PLAN AND SECTION	43.	HATCHERY BUILDING ARCHITECTURAL ROOF PLAN	66.	CHLORINATION - DECHLORINATION BUILDING ARCHITECTURAL ROOF PLAN AND DETAILS	83B.	REARING PONDS LOAD-OUT SCREEN DETAILS
18.	HAYDEN BRIDGE HOT WATER PIPELINE CROSSING SECTIONS AND DETAILS	44.	HATCHERY BUILDING ARCHITECTURAL ELEVATIONS	67.	CHLORINATION - DECHLORINATION BUILDING ARCHITECTURAL BUILDING ELEVATIONS	84.	REARING PONDS MISCELLANEOUS DETAILS
19.	HIGHWAY AND RAILROAD CROSSING PROFILES	45.	HATCHERY BUILDING ARCHITECTURAL SECTIONS	68.	CHLORINATION - DECHLORINATION BUILDING ARCHITECTURAL BUILDING SECTIONS AND DETAILS	85.	WASTEWATER BASINS PLAN AND SECTION
20.	HIGHWAY CROSSING PROFILE AND MISCELLANEOUS PIPELINE DETAILS	46.	HATCHERY BUILDING ARCHITECTURAL WALL SECTIONS			86.	WASTEWATER BASINS DETAILS
21.	EFFLUENT LINE PROFILES	47.	HATCHERY BUILDING ARCHITECTURAL WALL SECTIONS			87.	WASTEWATER BASINS STRUCTURAL DETAILS
22.	MISCELLANEOUS PIPING PROFILES	48.	HATCHERY BUILDING ARCHITECTURAL WALL SECTIONS			88.	ARCHITECTURAL DOOR AND HARDWARE SCHEDULES
23.	OUTFALL LINE PLAN, PROFILE, AND SECTION	49.	HATCHERY BUILDING ARCHITECTURAL WALL SECTIONS			89.	ARCHITECTURAL DETAILS
24.	MISCELLANEOUS PIPING DETAILS	50.	HATCHERY BUILDING ARCHITECTURAL WALL SECTIONS			90.	ARCHITECTURAL DETAILS
25.	MISCELLANEOUS PIPING DETAILS					91.	ARCHITECTURAL DETAILS
26.	MISCELLANEOUS PIPING DETAILS					92.	ARCHITECTURAL DETAILS
27.	VALVE VAULTS PLAN AND SECTIONS					93.	ARCHITECTURAL DETAILS
						94.	ARCHITECTURAL DETAILS
						95.	ARCHITECTURAL DETAILS
						96.	STRUCTURAL DETAILS
						97.	STRUCTURAL DETAILS
						98.	STRUCTURAL DETAILS

BY REVIEW TO INCL BY	TO	BY	DATE	NO.	REVISIONS
	CIV/STR	Mech	ELC	PR COM	HUM FAC
ADDENDUM NO. 1 CONTRACT SUPPLEMENT NO. 2					
THIS DRAWING IS THE PROPERTY OF THE WEYERHAEUSER COMPANY. IT IS LOANED AND IS TO BE RETURNED UPON REQUEST. THE DESIGNS AND IDEAS SHOWN HEREON ARE THE PROPERTY OF THE WEYERHAEUSER COMPANY AND SHALL NOT BE USED, DISCLOSED TO OTHERS, OR COPIED, IN WHOLE OR IN PART, WITHOUT WRITTEN PERMISSION.					
Corporate Engineering Tacoma, Washington		DESIGNED BY APP. PAPER DWN. D.S.P. CHK. T.Y.C.M.		PROJECT TITLE & LOCATION FRESHWATER HATCHERY SPRINGFIELD, OREGON	
SCALE AS SHOWN		APPROVAL DATE 6/8/32		SHEET D - 1 OF 98	
REV. C.E. DRAWING NO. 6832		PROJECT AREA		CH2M HILL	