
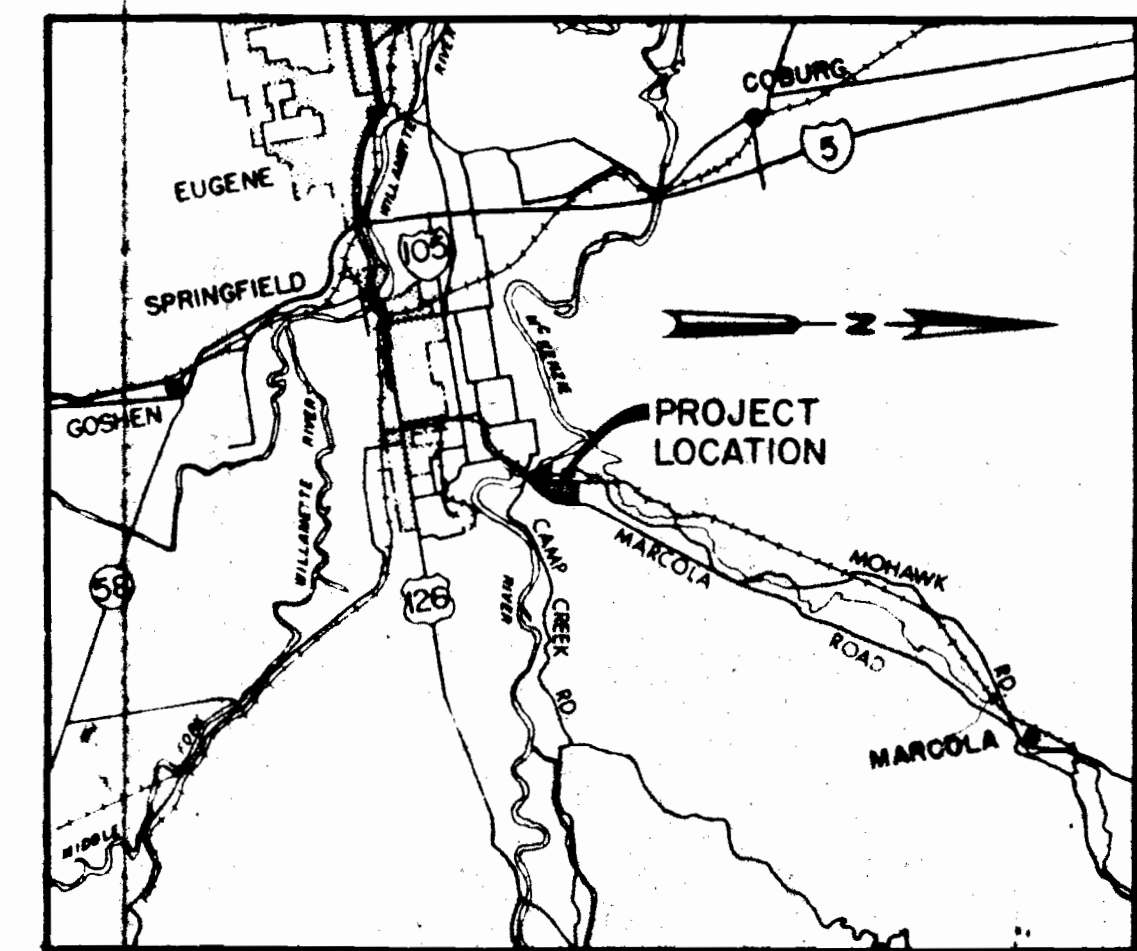


WEYERHAEUSER COMPANY


FRESHWATER HATCHERY

GENERAL

SPRINGFIELD, OREGON

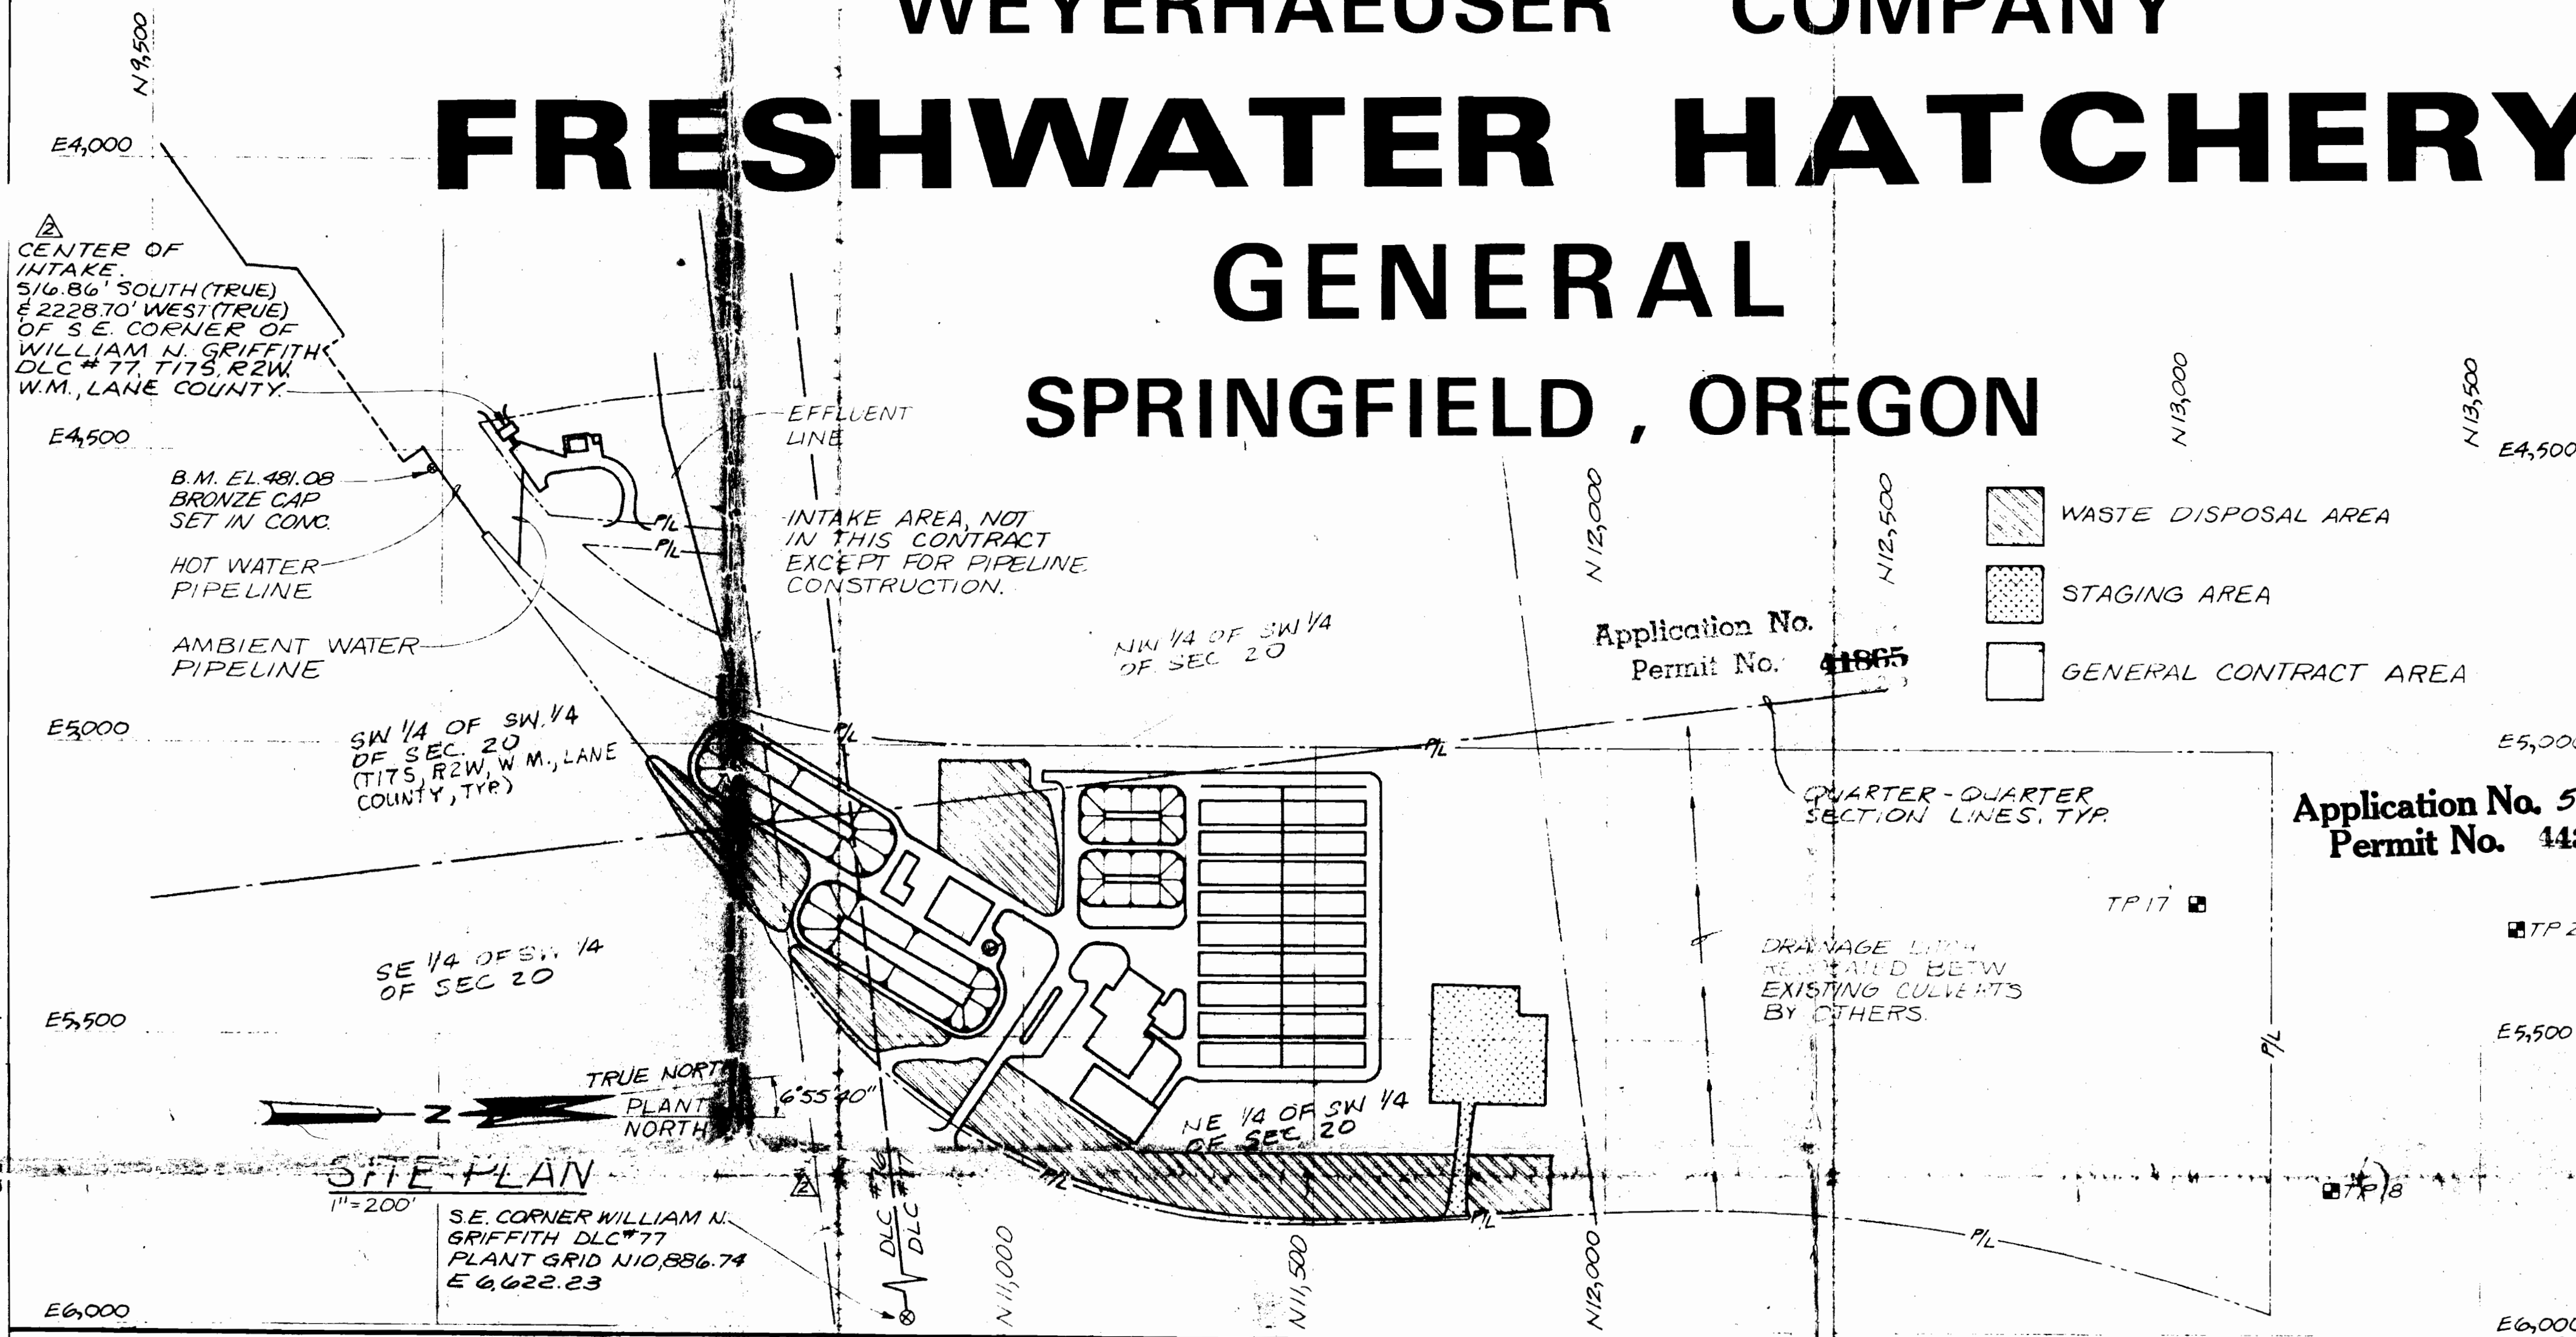

LOCATION MAP
1 2 3 4 5 6 7
APPROX. MILES

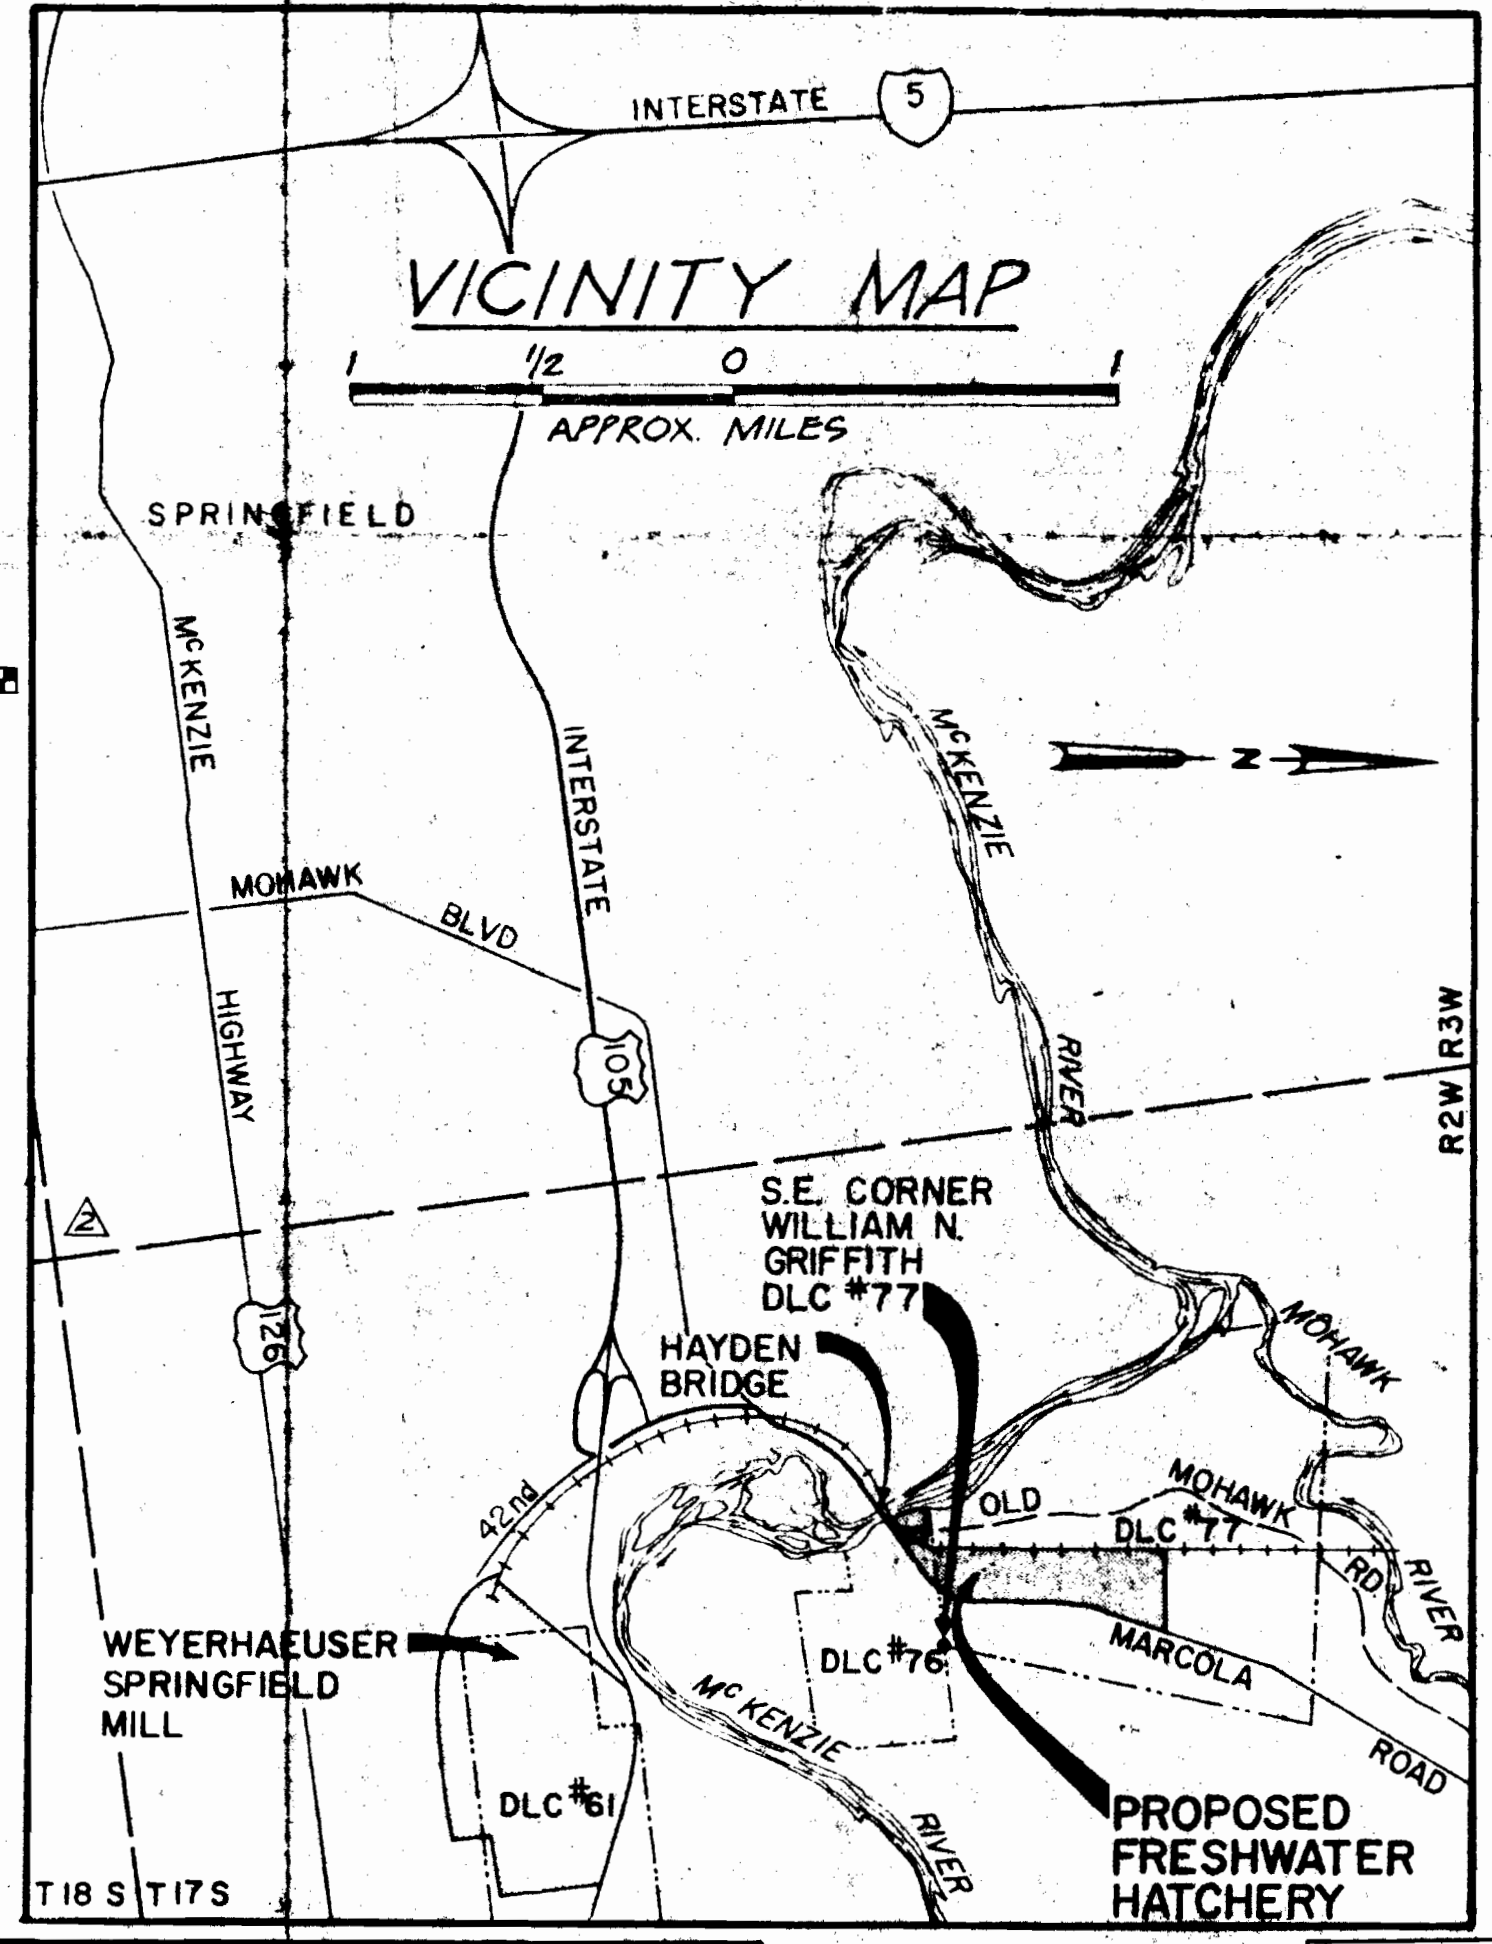

VICINITY MAP
1/2 0 1
APPROX. MILES

- WASTE DISPOSAL AREA
- STAGING AREA
- GENERAL CONTRACT AREA

Application No. 41865
Permit No. 41865

Application No. 58898
Permit No. 44391

SHEET NO.	DRAWING TITLE	SHEET NO.	DRAWING TITLE	SHEET NO.	DRAWING TITLE	SHEET NO.	DRAWING TITLE
1.	SITE PLAN, VICINITY MAP AND INDEX TO DRAWINGS	28.	SANITARY WASTE HOLDING TANK, AND MISCELLANEOUS DETAILS	51.	HATCHERY BUILDING STRUCTURAL FOUNDATION DETAILS	69.	CHLORINATION - DECHLORINATION BUILDING EQUIPMENT AND PIPING LAYOUT PLAN
2.	LEGEND	29.	R & D AND SERVICE WATER SUPPLY PUMP STATION LAYOUT AND GRADING PLAN	52.	HATCHERY BUILDING STRUCTURAL DETAILS	70.	CHLORINATION - DECHLORINATION BUILDING EQUIPMENT AND PIPING LAYOUT SECTIONS AND DETAILS
3.	LEGEND	30.	SEDIMENTATION BASIN PLAN AND SECTION	53.	HATCHERY BUILDING STRUCTURAL DETAILS	71.	CHLORINATION - DECHLORINATION BUILDING EQUIPMENT AND PIPING LAYOUT SCHEMATICS
4.	TEST PIT AND BORING LOG LOCATION PLAN	31.	SEDIMENTATION BASIN BASIN AND SECTION	54.	HATCHERY BUILDING STRUCTURAL DETAILS	72.	CHLORINATION - DECHLORINATION BUILDING CHLORINE DIFFUSER DETAILS
5.	TEST PIT AND BORING LOGS	32.	SEDIMENTATION BASIN BASIN DETAILS	55.	HATCHERY BUILDING ARCHITECTURAL PARTIAL PLANS AND INTERIOR ELEVATIONS	73.	CHLORINATION - DECHLORINATION BUILDING HEATING AND VENTILATING PLAN
6.	TEST PIT LOGS	33.	SEDIMENTATION BASIN OUTLET STRUCTURE DETAILS	56.	HATCHERY BUILDING ARCHITECTURAL PARTIAL PLANS, INTERIOR ELEVATIONS AND WINDOW ELEVATIONS	74.	REARING PONDS GENERAL LAYOUT PLAN
7.	SITE GRADING PLAN	34.	NOT USED	57.	HATCHERY BUILDING ARCHITECTURAL REFLECTED CEILING PLAN	75.	REARING PONDS PARTIAL FOUNDATION PLAN
8.	SITE LAYOUT PLAN	35.	AMBIENT WATER RETENTION BASIN LAYOUT PLAN AND SECTIONS	58.	HATCHERY BUILDING POTABLE WATER TREATMENT FACILITY HVAC PLAN	76.	REARING PONDS FISH LOAD-OUT FACILITY PLAN
9.	EARTHWORK SECTIONS	36.	HOT WATER RETENTION TANK STRUCTURAL PLAN SECTION AND DETAILS	59.	HATCHERY BUILDING POTABLE WATER TREATMENT FACILITY HVAC SECTIONS AND DETAILS	77.	REARING PONDS FISH LOAD-OUT FACILITY SECTIONS
10.	EARTHWORK SECTIONS	36A.	HOT WATER RETENTION TANK MECHANICAL PLAN SECTION AND DETAILS	60.	HATCHERY BUILDING POTABLE WATER TREATMENT FACILITY HVAC MISCELLANEOUS DETAILS	78.	REARING POND STRUCTURAL SECTIONS AND DETAILS
11.	EARTHWORK SECTIONS	37.	HOT WATER RETENTION TANK PIPING DETAILS	61.	HATCHERY BUILDING POTABLE WATER TREATMENT FACILITY PLUMBING PLAN	79.	REARING PONDS STRUCTURAL SECTIONS AND DETAILS
12.	MISCELLANEOUS DETAILS	38.	RETENTION BASIN FLOW CONTROL BOXES APPURTENANT INSTALLATION DETAILS	62.	HATCHERY BUILDING POTABLE WATER TREATMENT FACILITY PLUMBING SECTIONS AND DETAILS	80.	REARING PONDS FISH LOAD-OUT RETAINING WALL ELEVATIONS
13.	ENTRANCE ROAD PROFILE AND MISCELLANEOUS DETAILS	39.	RETENTION BASIN FLOW CONTROL BOXES APPURTENANT INSTALLATION DETAILS	63.	HATCHERY BUILDING POTABLE WATER TREATMENT FACILITY PLUMBING PLAN AND SECTIONS	81.	REARING PONDS TYPICAL MECHANICAL PLAN AND SECTIONS
14.	SITE PIPING PLAN, NORTH	40.	HATCHERY BUILDING STRUCTURAL FOUNDATION PLAN	64.	CHLORINATION - DECHLORINATION BUILDING ARCHITECTURAL FLOOR PLAN	82.	REARING PONDS GATE AND SECTION DETAILS
15.	SITE PIPING PLAN, SOUTH	41.	HATCHERY BUILDING ARCHITECTURAL FLOOR PLAN	65.	CHLORINATION - DECHLORINATION BUILDING ARCHITECTURAL FLOOR PLAN	83.	REARING PONDS GATE AND SCREEN DETAILS
16.	SITE PLUMBING PLAN	42.	HATCHERY BUILDING STRUCTURAL ROOF FRAMING PLAN	66.	CHLORINATION - DECHLORINATION BUILDING STRUCTURAL ROOF FRAMING PLAN AND DETAILS	84.	REARING PONDS LOAD-OUT CHUTE DETAILS
17.	HAYDEN BRIDGE HOT WATER PIPELINE CROSSING PLAN AND SECTION	43.	HATCHERY BUILDING ARCHITECTURAL ROOF PLAN	67.	CHLORINATION - DECHLORINATION BUILDING ARCHITECTURAL ROOF FRAMING PLAN AND DETAILS	85.	REARING PONDS LOAD-OUT SCREEN DETAILS
18.	HAYDEN BRIDGE HOT WATER PIPELINE CROSSING SECTIONS AND DETAILS	44.	HATCHERY BUILDING ARCHITECTURAL ELEVATIONS	68.	CHLORINATION - DECHLORINATION BUILDING ARCHITECTURAL BUILDING ELEVATIONS	86.	WASTEWATER BASINS PLAN AND SECTION
19.	HIGHWAY AND RAILROAD CROSSING PROFILES	45.	HATCHERY BUILDING ARCHITECTURAL SECTIONS	69.	CHLORINATION - DECHLORINATION BUILDING ARCHITECTURAL BUILDING ELEVATIONS	87.	WASTEWATER BASINS DETAILS
20.	HIGHWAY CROSSING PROFILE AND MISCELLANEOUS PIPELINE DETAILS	46.	HATCHERY BUILDING ARCHITECTURAL WALL SECTIONS	70.	CHLORINATION - DECHLORINATION BUILDING ARCHITECTURAL BUILDING SECTIONS AND DETAILS	88.	ARCHITECTURAL DOOR AND HARDWARE SCHEDULES
21.	EFFLUENT LINE PROFILES	47.	HATCHERY BUILDING ARCHITECTURAL WALL SECTIONS	71.	CHLORINATION - DECHLORINATION BUILDING ARCHITECTURAL BUILDING SECTIONS AND DETAILS	89.	ARCHITECTURAL DETAILS
22.	MISCELLANEOUS PIPING PROFILES	48.	HATCHERY BUILDING ARCHITECTURAL WALL SECTIONS	72.	CHLORINATION - DECHLORINATION BUILDING ARCHITECTURAL BUILDING SECTIONS AND DETAILS	90.	ARCHITECTURAL DETAILS
23.	OUTFALL LINE PLAN, PROFILE, AND SECTIONS	49.	HATCHERY BUILDING ARCHITECTURAL WALL SECTIONS	73.	CHLORINATION - DECHLORINATION BUILDING ARCHITECTURAL BUILDING SECTIONS AND DETAILS	91.	ARCHITECTURAL DETAILS
24.	MISCELLANEOUS PIPING DETAILS	50.	HATCHERY BUILDING ARCHITECTURAL WALL SECTIONS	74.	CHLORINATION - DECHLORINATION BUILDING ARCHITECTURAL BUILDING SECTIONS AND DETAILS	92.	ARCHITECTURAL DETAILS
25.	MISCELLANEOUS PIPING DETAILS			75.	CHLORINATION - DECHLORINATION BUILDING ARCHITECTURAL BUILDING SECTIONS AND DETAILS	93.	ARCHITECTURAL DETAILS
26.	MISCELLANEOUS PIPING DETAILS			76.	CHLORINATION - DECHLORINATION BUILDING ARCHITECTURAL BUILDING SECTIONS AND DETAILS	94.	ARCHITECTURAL DETAILS
27.	VALVE VAULTS PLAN AND SECTIONS			77.	CHLORINATION - DECHLORINATION BUILDING ARCHITECTURAL BUILDING SECTIONS AND DETAILS	95.	ARCHITECTURAL DETAILS
				78.	CHLORINATION - DECHLORINATION BUILDING ARCHITECTURAL BUILDING SECTIONS AND DETAILS	96.	STRUCTURAL DETAILS
				79.	CHLORINATION - DECHLORINATION BUILDING ARCHITECTURAL BUILDING SECTIONS AND DETAILS	97.	STRUCTURAL DETAILS
				80.	CHLORINATION - DECHLORINATION BUILDING ARCHITECTURAL BUILDING SECTIONS AND DETAILS	98.	STRUCTURAL DETAILS

THIS DRAWING IS THE PROPERTY OF THE WEYERHAEUSER COMPANY. IT IS LOANED TO YOU FOR YOUR INFORMATION AND IS TO BE RETURNED UPON REQUEST. THE DESIGN AND IDEAS SHOWN HEREON ARE THE PROPERTY OF THE WEYERHAEUSER COMPANY AND SHALL NOT BE USED, DISCLOSED TO OTHERS, OR COPIED, IN WHOLE OR IN PART, WITHOUT WRITTEN PERMISSION.

DATE: 10/1/88
NO. 10/1/88
BY: [Signature]
TO: [Signature]
REV: [Signature]
CIV. STR. [Signature]
MECH. [Signature]
ELEC. [Signature]
PL. [Signature]
HUM. FAC. [Signature]
ENV. SYS. [Signature]

REVISIONS:
NO. 1: 10/1/88
NO. 2: 10/1/88
NO. 3: 10/1/88
NO. 4: 10/1/88
NO. 5: 10/1/88
NO. 6: 10/1/88
NO. 7: 10/1/88
NO. 8: 10/1/88
NO. 9: 10/1/88
NO. 10: 10/1/88

PROJECT TITLE & LOCATION:
FRESHWATER HATCHERY
SPRINGFIELD, OREGON

SCALE: AS SHOWN

APPROVAL DATE: 10/1/88

REV. C.E. DRAWING NO. 6832 - PROJECT AREA

CH2M HILL



20

Place of Use

W.W. Cor.
DLC No. 76

SE Cor.
DLC No. 77

NE Cor.
DLC No. 78

W.W. Cor.
DLC No. 76

19 20
30 29

20 21
29 28

SW Cor.
DLC No. 76

SE Cor.
DLC No. 76

W.W. Cor.
DLC No. 49

NE Cor.
DLC No. 59

SE Cor.
DLC No. 82

N.W. Cor.
DLC No. 80

W.W. Cor.
DLC No. 61

SW Cor.
DLC No. 49

W.W. Cor.
DLC No. 61

SW Cor.
DLC No. 59

W.W. Cor.
DLC No. 81

30 29
31 32

29 28
32 33

SE Cor.
DLC No. 80

Point of Diversion

T.T.S. R2W

RECEIVED

OCT 13 1982

WATER RESOURCES DEPT.
SALEM, OREGON

Approximate Scale: 1" = 500'

Photo Date: 1-27-80