


WATER RESOURCES DEPARTMENT
 APPROVED: *Ad 7 19 86*
William N. Young
 DIRECTOR
 379
 ENGINEER JOHN LOONEY, SALEM

DEPARTMENT OF WATER RESOURCES
 DO NOT SEND OUT

Application No. *68043 & R-68679*
 Permit No. *49870* *R10814*

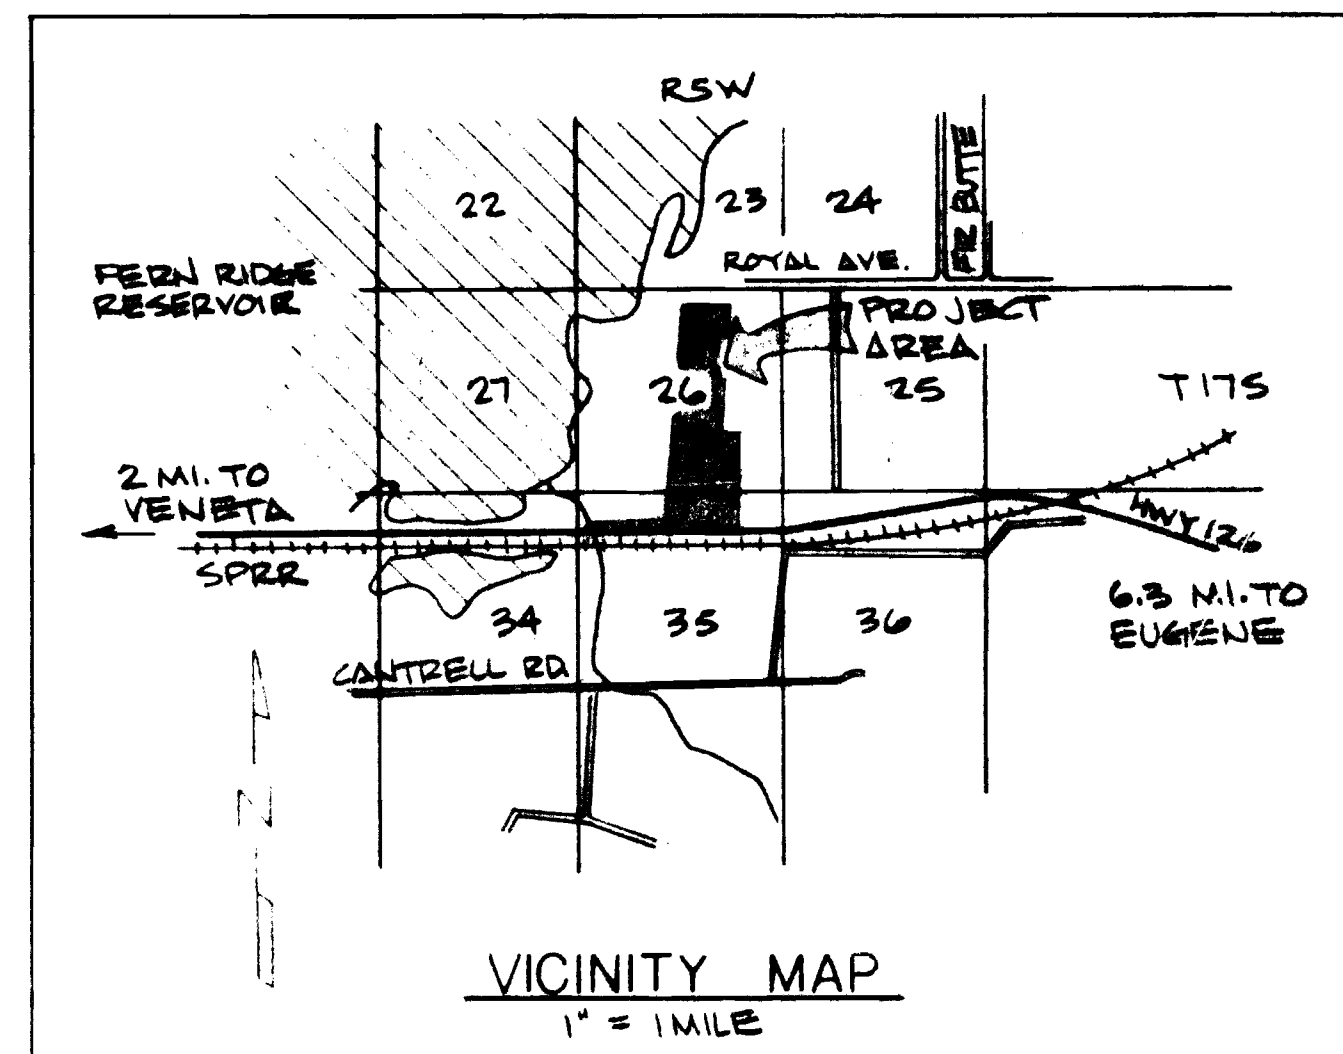

SITE PLAN
 SCALE: 1" = 400'

T175 RSW W.M. SECS 26 & 35

- COMPLETED AS OF JULY 1, 1984
- FIELD NO 1
 - CANAL FOR FIELD NO 1
 - INTAKE AND IRRIGATION PIPELINE TO FIELD NO 1
- TO BE COMPLETED
- INTAKE DIKES & CANAL GATES
 - FIELDS 2 THRU 7
 - CANAL FROM FIELD 2 THRU 5

5-21-86 ADD POINT OF DIVERSION
 3-1-86 P.M. & NOTE
 REVISIONS

DATE FEB. 19, 1986
 DESIGN BY ODFW
 DRAWN BY BJ
 CHECKED BY PRJ

DEPARTMENT OF FISH & WILDLIFE
 STATE OF OREGON
 FERN RIDGE W.M.A.
 PHASE III DEVELOPMENT
 SITE PLAN

APPROVED: _____
 DIRECTOR

FILE NO. *8516* SH. 1 OF 1